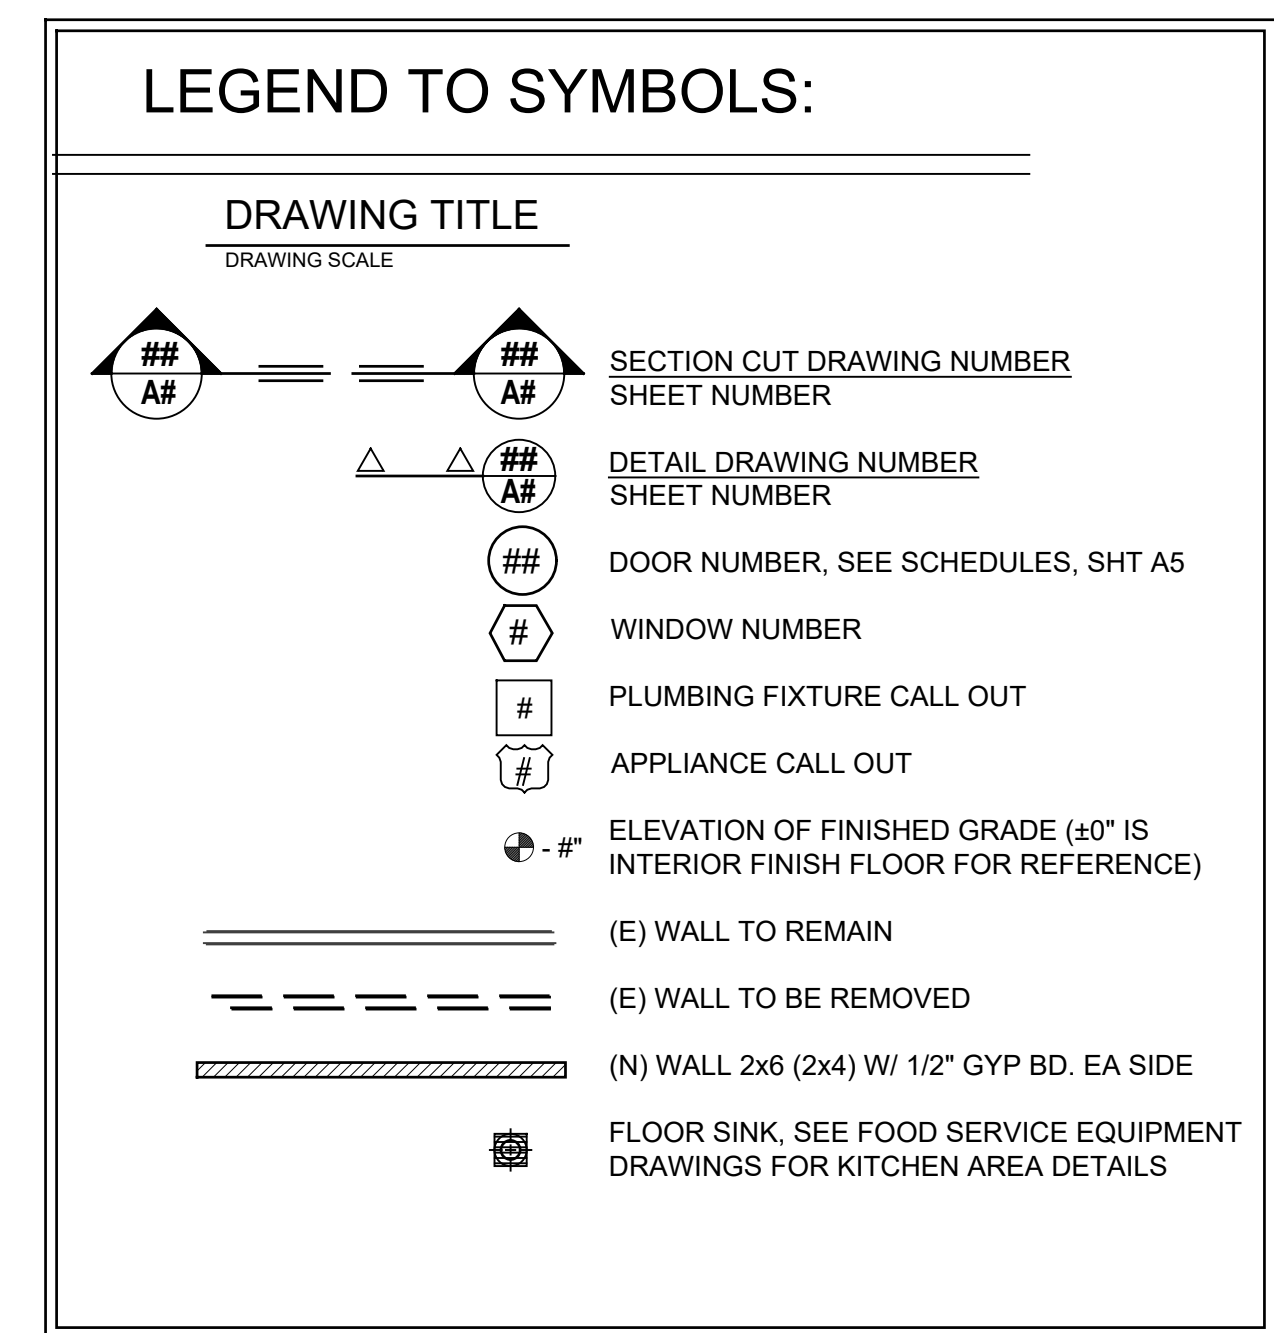




Kelly B. Grimes, Architect

P.O. Box 598
Little River, CA 95456
707-937-2904

REGISTERED ARCHITECT
KELLY B. GRIMES
C-28723
EXP. 8-31-25
STATE OF CALIFORNIA

The seal is circular with the text "REGISTERED ARCHITECT" at the top, "KELLY B. GRIMES" in the center, "C-28723" below the name, "EXP. 8-31-25" at the bottom, and "STATE OF CALIFORNIA" around the perimeter. To the right of the seal is a line drawing of a two-story house with a gabled roof and a palm tree in front of it.

REVISIONS	BY

NOTES:

REMODELED GROUND FLOOR PLAN
SCALE: 1/8" = 1'-0"

NEW WINDOW 5070 FIXED ALUMINUM TO MATCH EXISTING, TYPICAL 2 THIS WALL ONLY

ALL (E) WINDOWS TO BE REPLACED WITH DUAL GLAZED ALUMINUM, SEE WINDOW SCHEDULE, SHT A5

RESTRIPE ORIENTATION OF PARKING AREA THIS END

VERIFY (E) TOILET ACCESSIBLE

NEW EXTERIOR DOOR

(E) TUBESTEEL TO REMAIN

(E) FIXTURES TO REMAIN

UTILITY 115 SQFT

COMICS 1485 SQFT

ACCESSIBLE SINK PROVIDE TOE AND KNEE CLEARANCE BELOW

WASTE PIPE FROM ABOVE CUT AND CAP BELOW FLOOR

GAMING 755 SQFT

6040 TEMPERED WINDOW, TYP 2

DRINKING FOUNTAIN

DINING 1400 SQFT ~ 21'x68'

PIZZA BAR

SALAD BAR

WAREWASH

SERVERY

KITCHEN 2500 SQFT

VEG PREP

PREP ROOM

(N) EXIT SIGN ABOVE (N) DOOR FOR EMERGENCY EXIT ALARM WILL SOUND

REFRIG DOUGH STO

BANQUET 660 SQFT ~ 25' x 27'

CONCRETE PATIO AREA

REPLACE (E) WINDOW W/ NEW EXTERIOR DOOR

(E) WINDOWS TO REMAIN, TYPICAL

(E) CONCRETE BANK VAULT TO REMAIN

6"x3', 4 YARD GARBAGE BIN

GREASE TRAP

EXTEND CONCRETE, TO CREATESIDEWALK

(N) GENERATOR

(E) PROPANE SUPPLY TO BUILDING

NEW WINDOW 48x48

RAMP DN MAX 1:12

PLANTINGS

34" HIGH COUNTER W/ KNEE & TOE CLEARANCES

STORAGE AREA

BAR

ORDER/CHECKOUT

MAMA BEARS KITCHEN

WAIT SERVICE

LOCKERS

COOLER + NSF

LOCKERS

DRY STORAGE

6"x3', 4 YARD GARBAGE BIN

GREASE TRAP

(E) TUBESTEEL TO REMAIN

(E) FIXTURES TO REMAIN

UTILITY 115 SQFT

COMICS 1485 SQFT

ACCESSIBLE SINK PROVIDE TOE AND KNEE CLEARANCE BELOW

WASTE PIPE FROM ABOVE CUT AND CAP BELOW FLOOR

GAMING 755 SQFT

6040 TEMPERED WINDOW, TYP 2

DRINKING FOUNTAIN

DINING 1400 SQFT ~ 21'x68'

PIZZA BAR

SALAD BAR

WAREWASH

SERVERY

KITCHEN 2500 SQFT

VEG PREP

PREP ROOM

(N) EXIT SIGN ABOVE (N) DOOR FOR EMERGENCY EXIT ALARM WILL SOUND

REFRIG DOUGH STO

BANQUET 660 SQFT ~ 25' x 27'

CONCRETE PATIO AREA

REPLACE (E) WINDOW W/ NEW EXTERIOR DOOR

(E) WINDOWS TO REMAIN, TYPICAL

(E) CONCRETE BANK VAULT TO REMAIN

6"x3', 4 YARD GARBAGE BIN

GREASE TRAP

EXTEND CONCRETE, TO CREATESIDEWALK

(N) GENERATOR

(E) PROPANE SUPPLY TO BUILDING

NEW WINDOW 48x48

RAMP DN MAX 1:12

PLANTINGS

34" HIGH COUNTER W/ KNEE & TOE CLEARANCES

STORAGE AREA

BAR

ORDER/CHECKOUT

MAMA BEARS KITCHEN

WAIT SERVICE

LOCKERS

COOLER + NSF

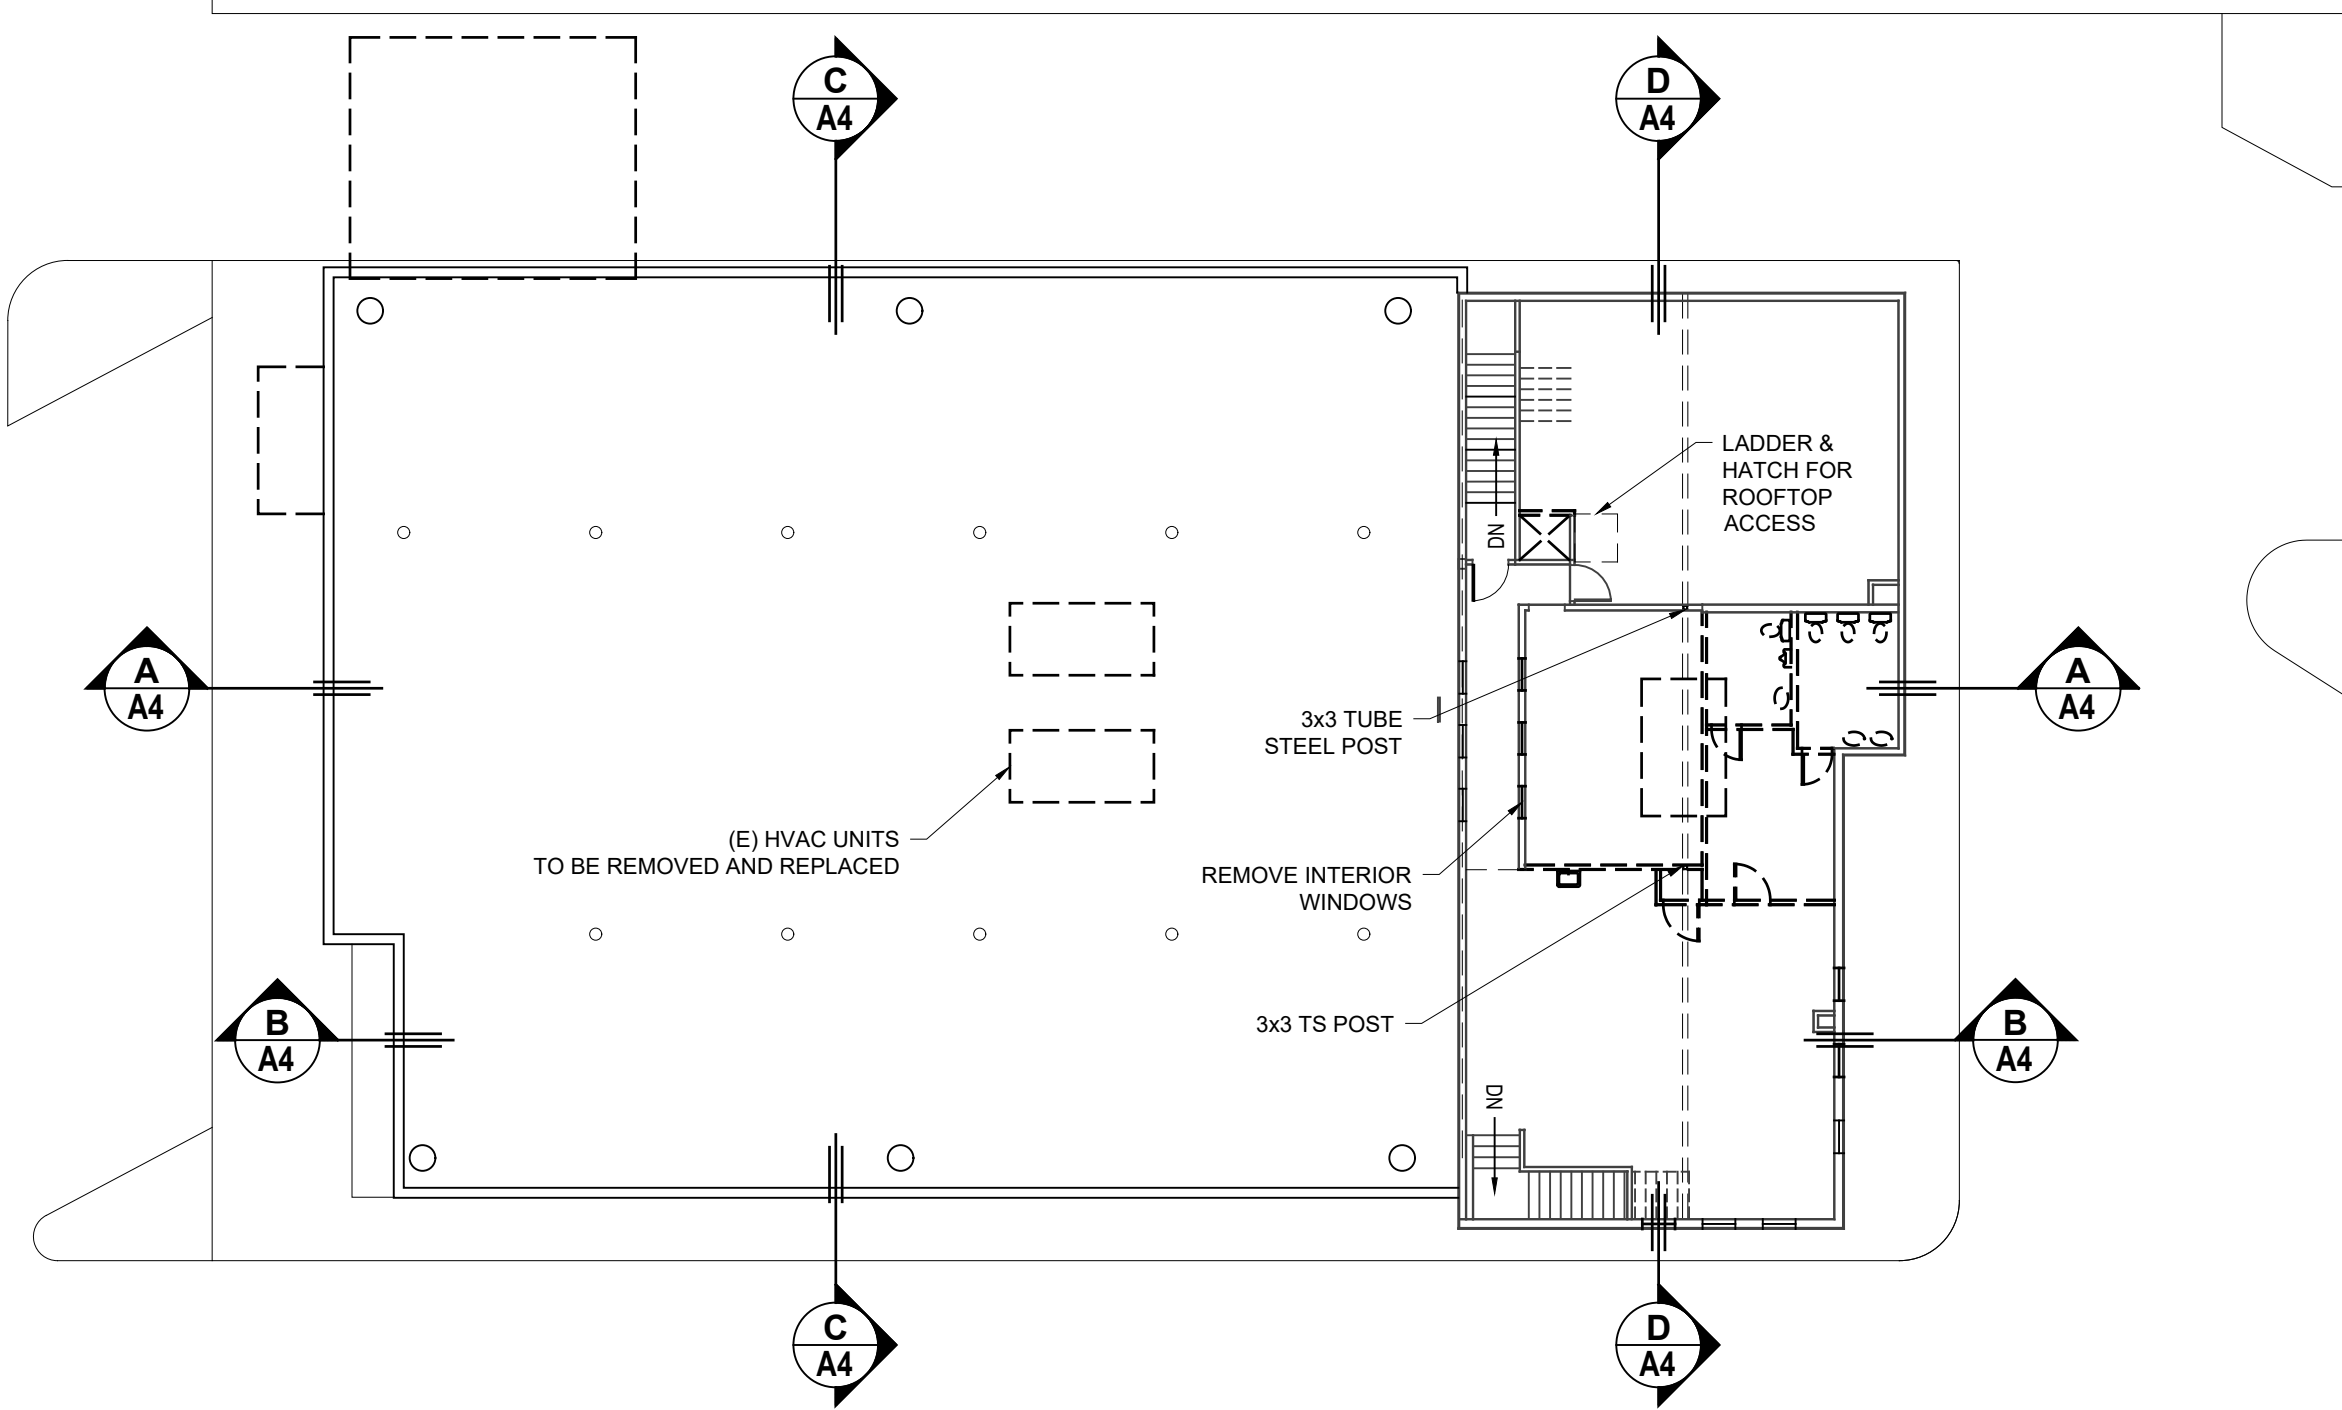
LOCKERS

DRY STORAGE

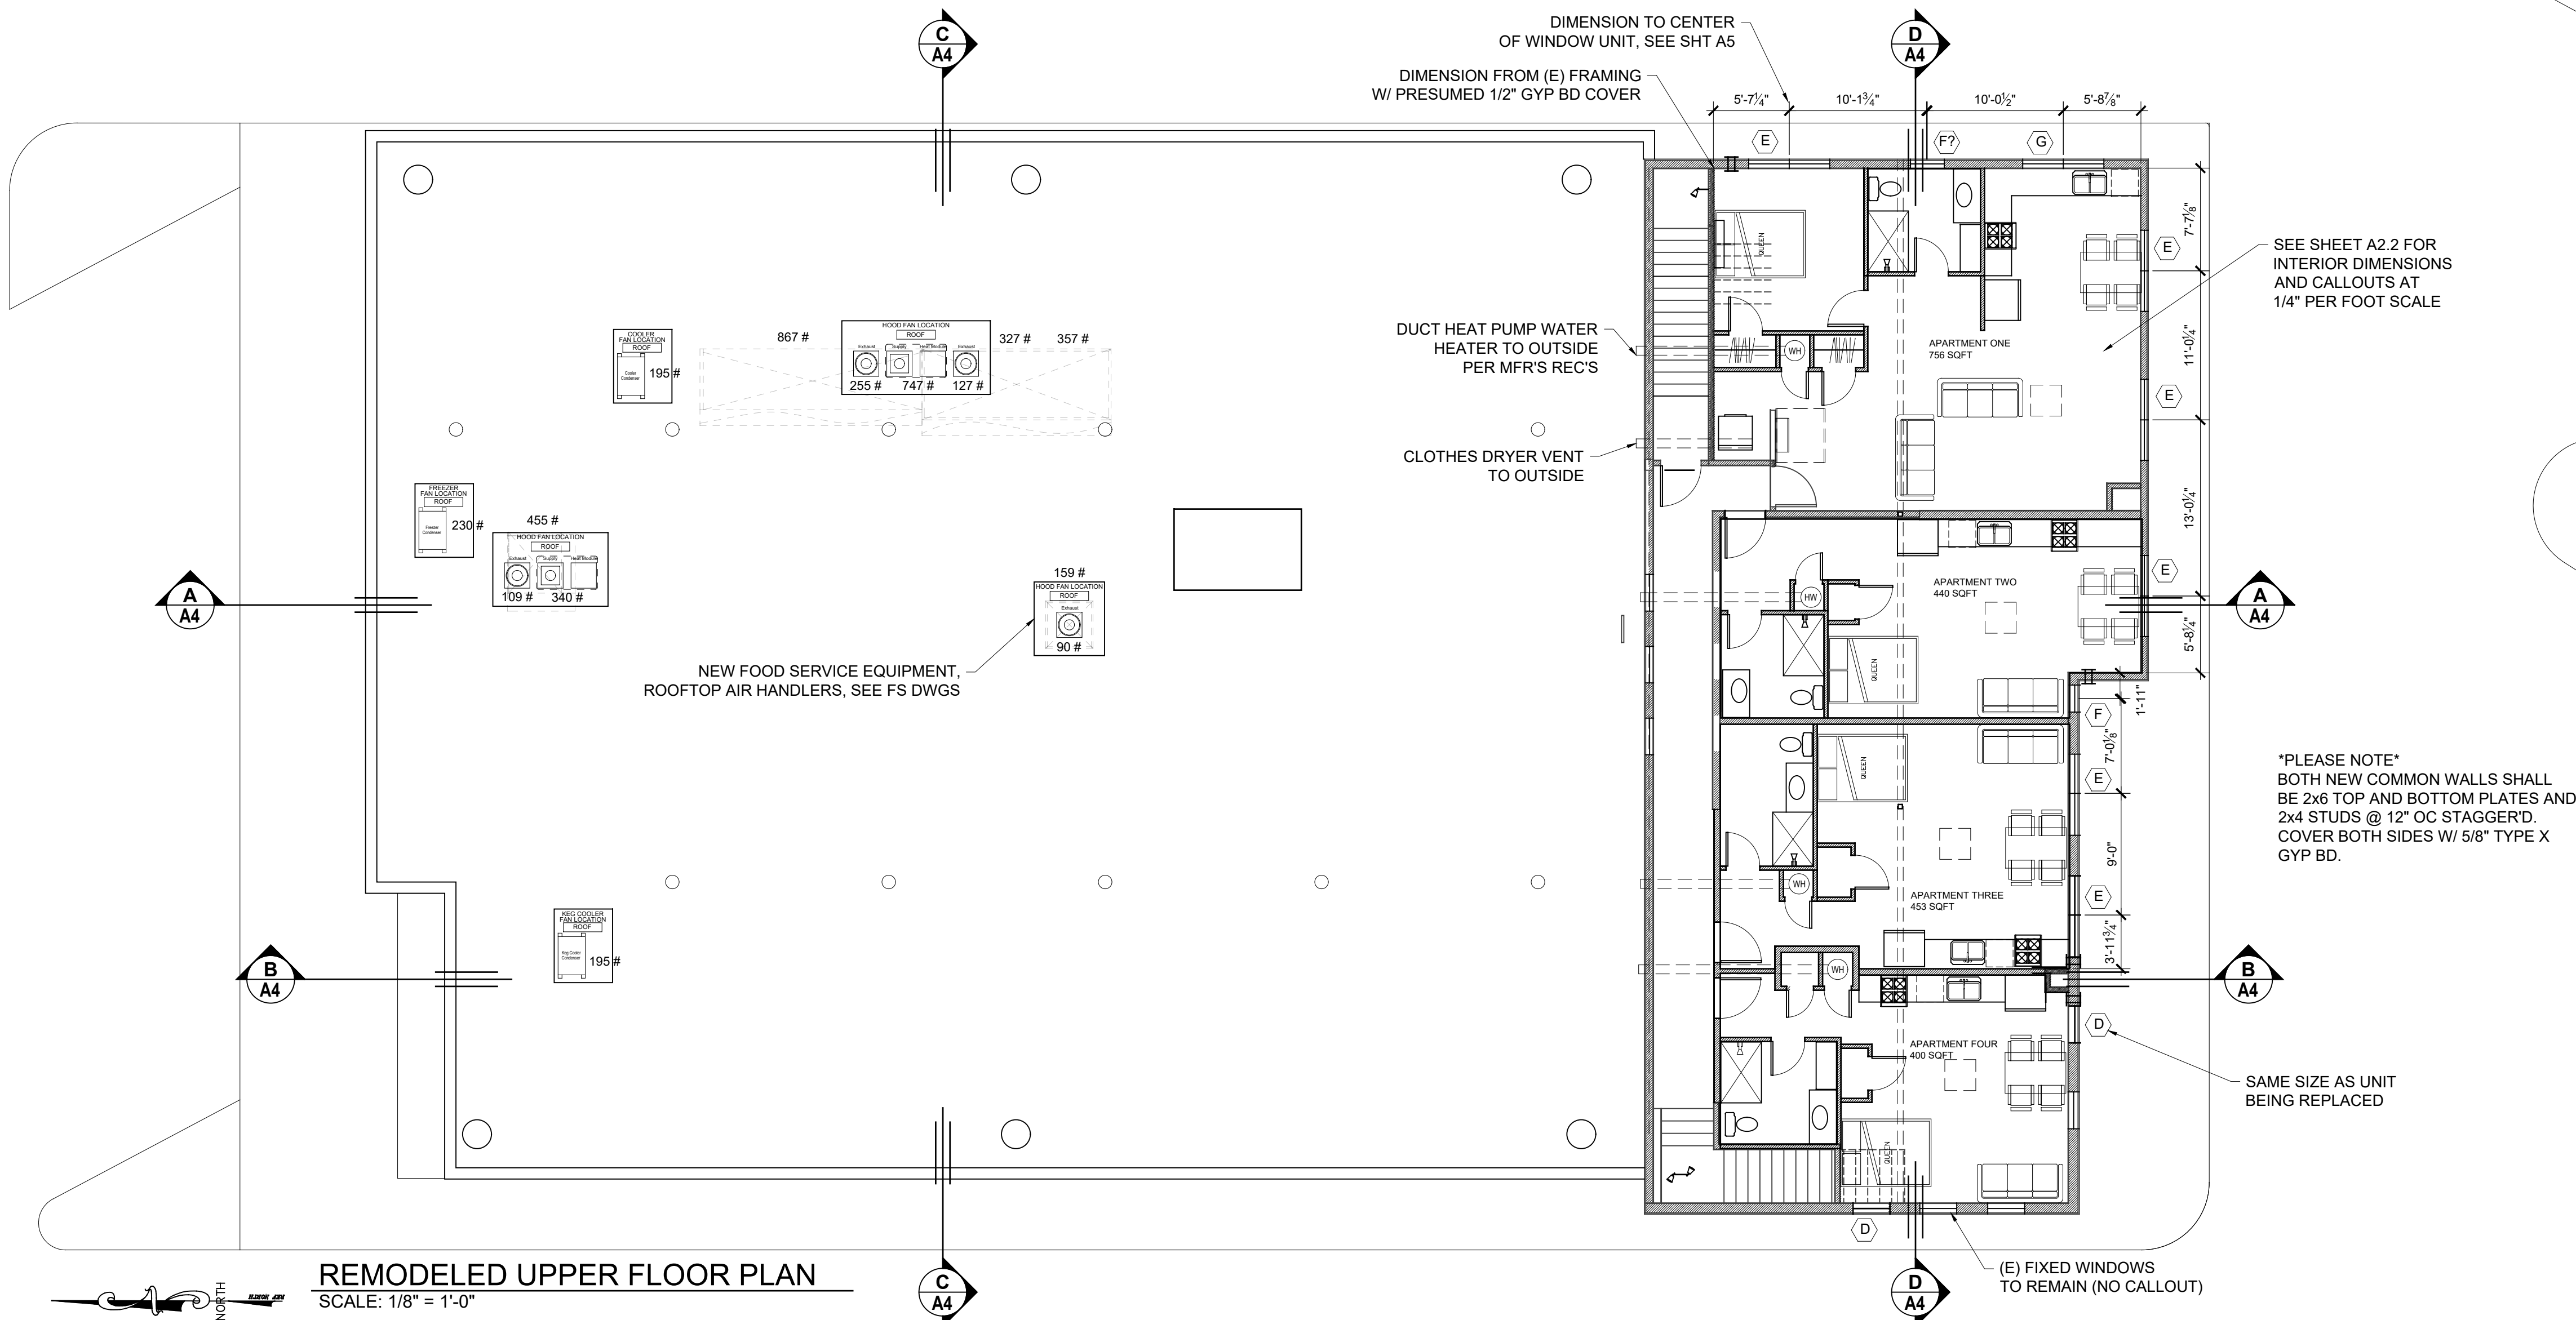
- RESTRIPE ORIENTATION OF
PARKING AREA THIS END

A2

OF - SHEETS



(E) UPPER FLOOR PLAN
SCALE: 1/16" = 1'-0"



REMODELED UPPER FLOOR PLAN
SCALE: 1/8" = 1'-0"

LEGEND TO SYMBOLS:

DRAWING TITLE

DRAWING SCALE

- SECTION CUT DRAWING NUMBER SHEET NUMBER
- DETAIL DRAWING NUMBER SHEET NUMBER
- DOOR NUMBER, SEE SCHEDULES, SHT A5
- WINDOW NUMBER
- PLUMBING FIXTURE CALL OUT
- APPLIANCE CALL OUT
- ELEVATION OF FINISHED GRADE (±0") IS INTERIOR FINISH FLOOR FOR REFERENCE
- (E) WALL TO REMAIN
- (E) WALL TO BE REMOVED
- (N) WALL 2x6 (2x4) W/ 1/2" GYP BD. EA SIDE
- FLOOR SINK. SEE FOOD SERVICE EQUIPMENT DRAWINGS FOR KITCHEN AREA DETAILS

Kelly B. Grimes, Architect
P.O. Box 598
Little River, CA 95456
707-937-2904

REGISTERED ARCHITECT
STATE OF CALIFORNIA
C-28723
EXP. 8-31-23

REVISIONS	BY

NOTES:

REMODELING PLANS FOR:

PAPA BEAR'S PIZZA
228 N. MAIN ST.
FORT BRAGG, CA 95437

A.P. #119-090-13

DATE: MARCH 20, 2023

SCALE: AS NOTED

DRAWN BY: KBG

JOB: POOS

SHEET:

UPPER FLOOR PLAN

A2.1

OF SHEETS

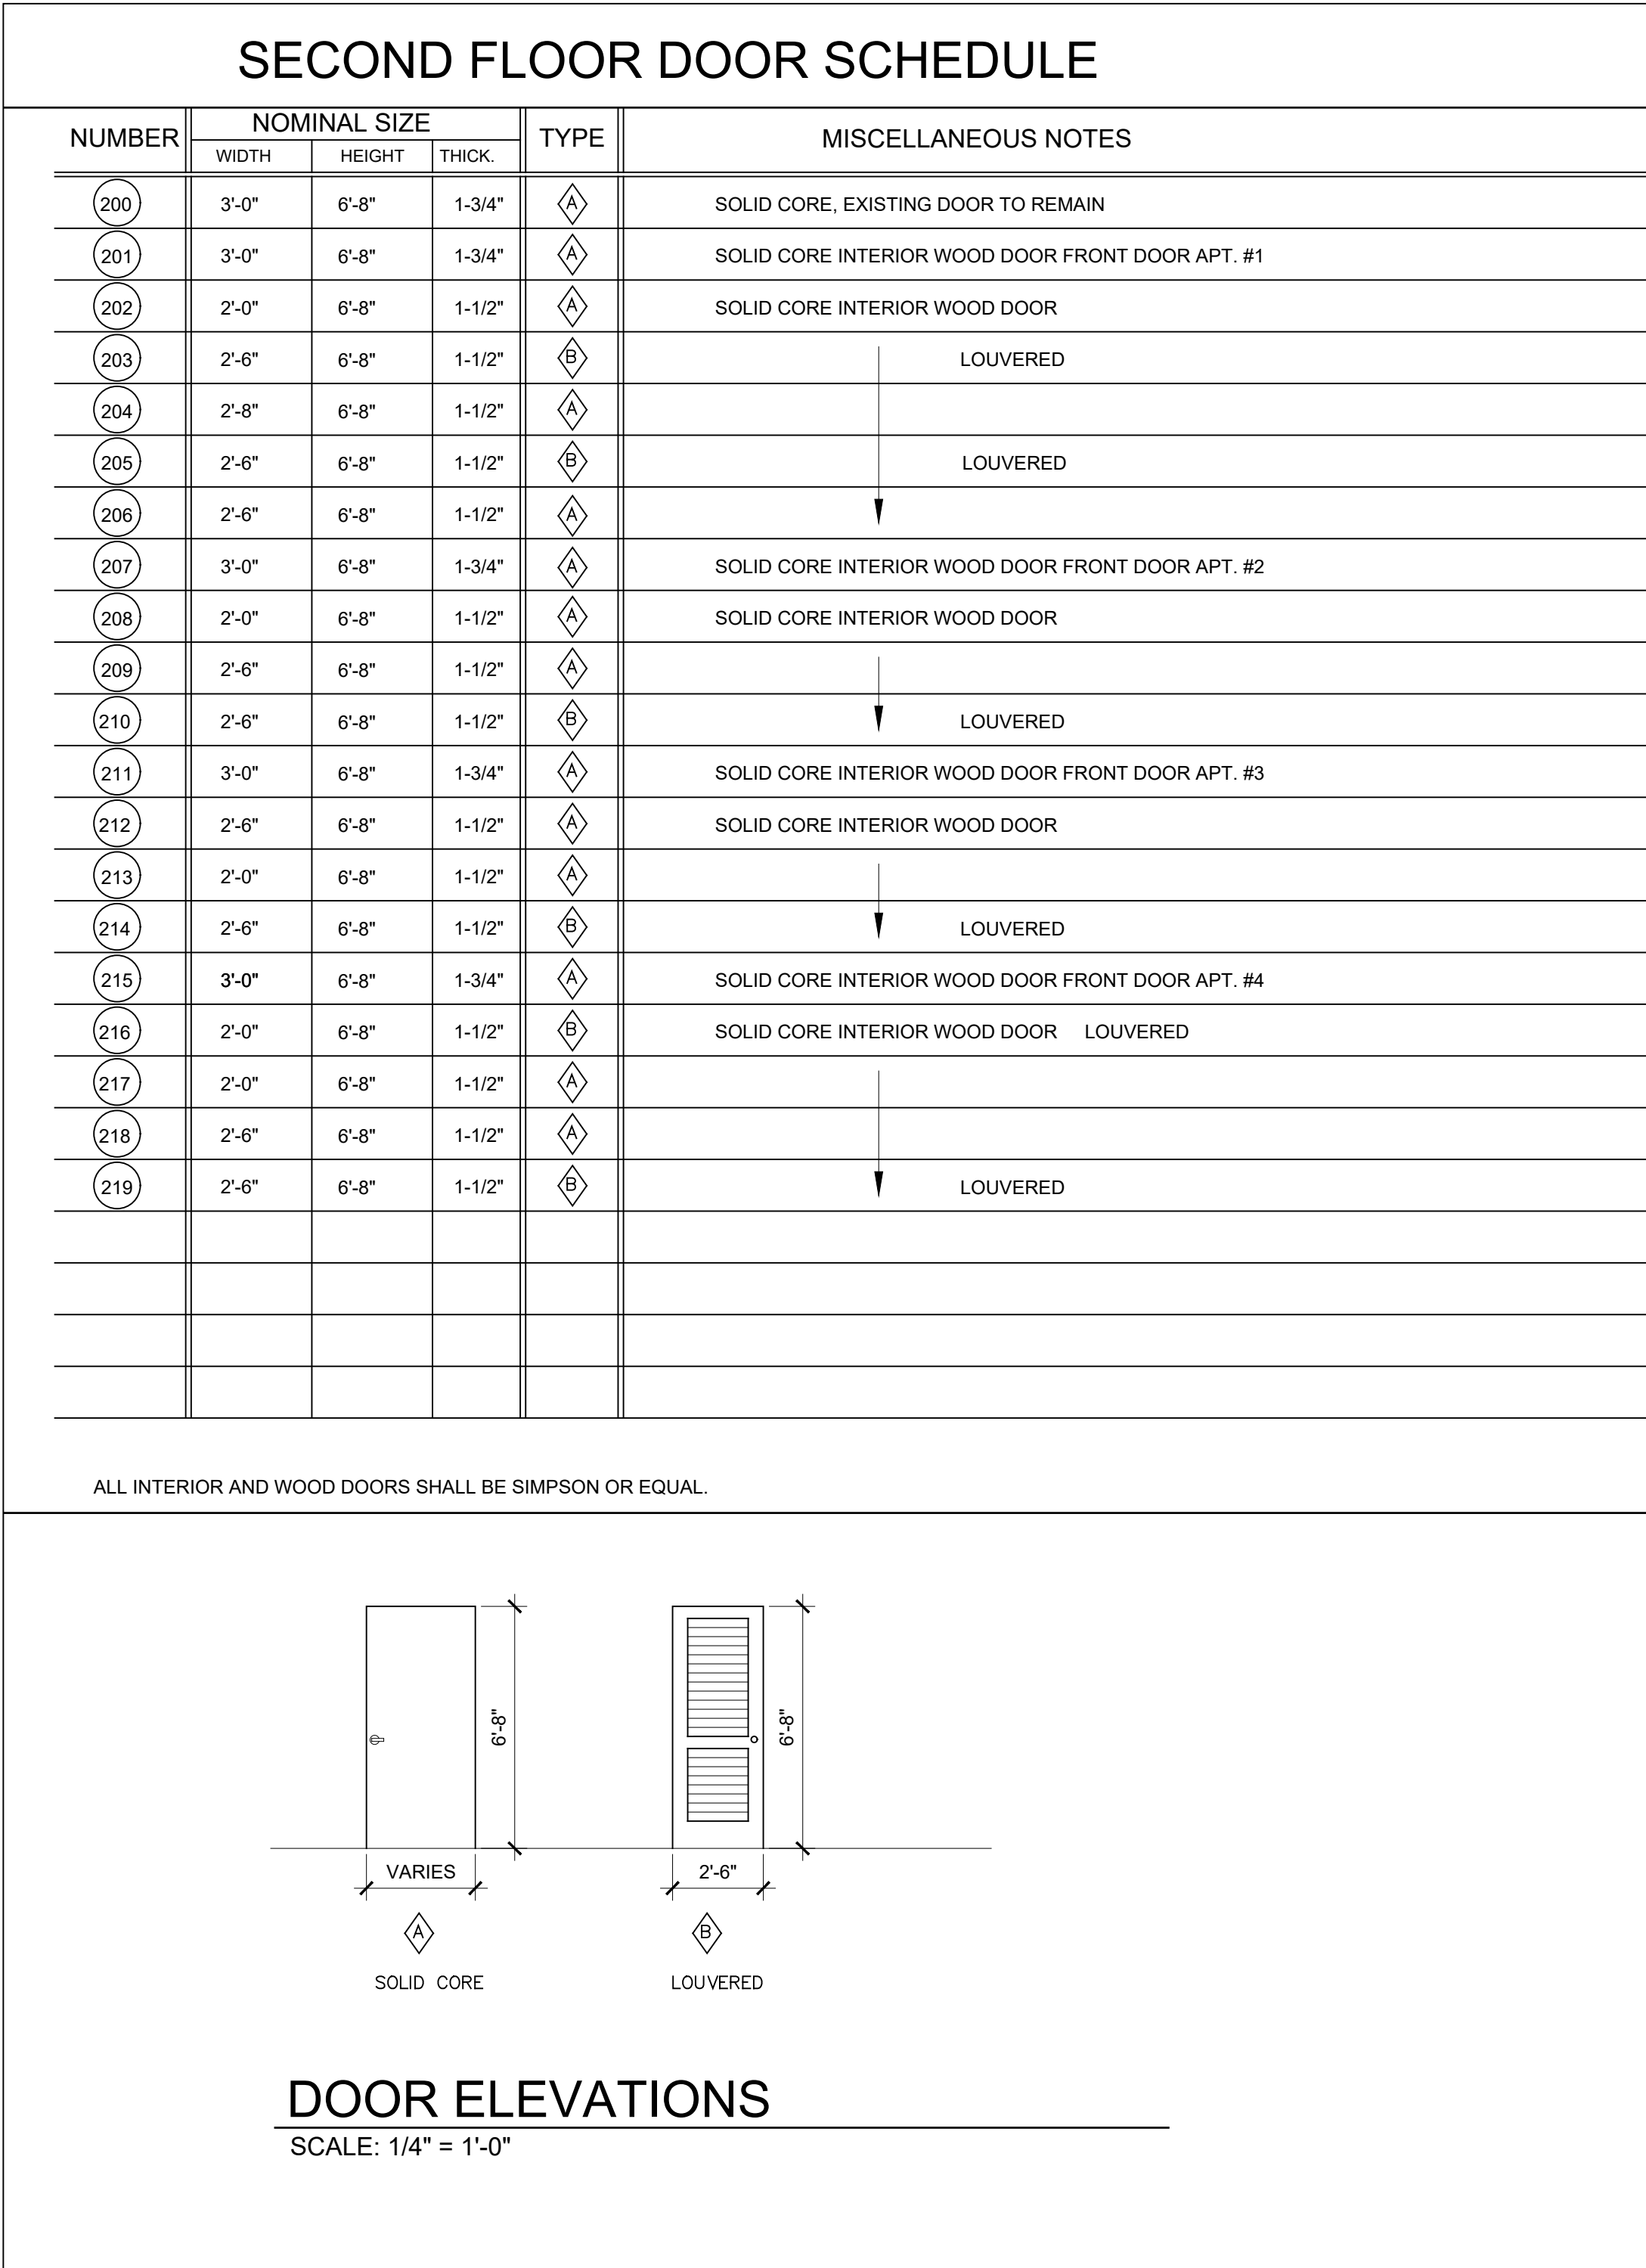
SECOND FLOOR DOOR SCHEDULE					
NUMBER	NOMINAL SIZE			TYPE	MISCELLANEOUS NOTES
	WIDTH	HEIGHT	THICK.		
(200)	3'-0"	6'-8"	1-3/4"		SOLID CORE, EXISTING DOOR TO REMAIN
(201)	3'-0"	6'-8"	1-3/4"		SOLID CORE INTERIOR WOOD DOOR FRONT DOOR APT. #1
(202)	2'-0"	6'-8"	1-1/2"		SOLID CORE INTERIOR WOOD DOOR
(203)	2'-6"	6'-8"	1-1/2"		LOUVERED
(204)	2'-8"	6'-8"	1-1/2"		
(205)	2'-6"	6'-8"	1-1/2"		LOUVERED
(206)	2'-6"	6'-8"	1-1/2"		
(207)	3'-0"	6'-8"	1-3/4"		
(208)	2'-0"	6'-8"	1-1/2"		SOLID CORE INTERIOR WOOD DOOR
(209)	2'-6"	6'-8"	1-1/2"		
(210)	2'-6"	6'-8"	1-1/2"		
(211)	3'-0"	6'-8"	1-3/4"		SOLID CORE INTERIOR WOOD DOOR FRONT DOOR APT. #3
(212)	2'-6"	6'-8"	1-1/2"		SOLID CORE INTERIOR WOOD DOOR
(213)	2'-0"	6'-8"	1-1/2"		
(214)	2'-6"	6'-8"	1-1/2"		
(215)	3'-0"	6'-8"	1-3/4"		SOLID CORE INTERIOR WOOD DOOR FRONT DOOR APT. #4
(216)	2'-0"	6'-8"	1-1/2"		SOLID CORE INTERIOR WOOD DOOR LOUVERED
(217)	2'-0"	6'-8"	1-1/2"		
(218)	2'-6"	6'-8"	1-1/2"		
(219)	2'-6"	6'-8"	1-1/2"		LOUVERED

ALL INTERIOR AND WOOD DOORS SHALL BE SIMPSON OR EQUAL.

SECOND FLOOR DOOR SCHEDULE						
NUMBER	NOMINAL SIZE			TYPE	MISCELLANEOUS NOTES	
	WIDTH	HEIGHT	THICK.			
200	3'-0"	6'-8"	1-3/4"		SOLID CORE, EXISTING DOOR TO REMAIN	
201	3'-0"	6'-8"	1-3/4"		SOLID CORE INTERIOR WOOD DOOR FRONT DOOR APT. #1	
202	2'-0"	6'-8"	1-1/2"		SOLID CORE INTERIOR WOOD DOOR	
203	2'-6"	6'-8"	1-1/2"		LOUVERED	
204	2'-8"	6'-8"	1-1/2"			
205	2'-6"	6'-8"	1-1/2"		LOUVERED	
206	2'-6"	6'-8"	1-1/2"			
207	3'-0"	6'-8"	1-3/4"		SOLID CORE INTERIOR WOOD DOOR FRONT DOOR APT. #2	
208	2'-0"	6'-8"	1-1/2"		SOLID CORE INTERIOR WOOD DOOR	
209	2'-6"	6'-8"	1-1/2"		LOUVERED	
210	2'-6"	6'-8"	1-1/2"			
211	3'-0"	6'-8"	1-3/4"		SOLID CORE INTERIOR WOOD DOOR FRONT DOOR APT. #3	
212	2'-6"	6'-8"	1-1/2"		SOLID CORE INTERIOR WOOD DOOR	
213	2'-0"	6'-8"	1-1/2"		LOUVERED	
214	2'-6"	6'-8"	1-1/2"			
215	3'-0"	6'-8"	1-3/4"		SOLID CORE INTERIOR WOOD DOOR FRONT DOOR APT. #4	
216	2'-0"	6'-8"	1-1/2"		SOLID CORE INTERIOR WOOD DOOR LOUVERED	
217	2'-0"	6'-8"	1-1/2"			
218	2'-6"	6'-8"	1-1/2"			
219	2'-6"	6'-8"	1-1/2"		LOUVERED	

ALL INTERIOR AND WOOD DOORS SHALL BE SIMPSON OR EQUAL.

SECOND FLOOR DOOR SCHEDULE						
NUMBER	NOMINAL SIZE			TYPE	MISCELLANEOUS NOTES	
	WIDTH	HEIGHT	THICK.			
200	3'-0"	6'-8"	1-3/4"		SOLID CORE, EXISTING DOOR TO REMAIN	
201	3'-0"	6'-8"	1-3/4"		SOLID CORE INTERIOR WOOD DOOR FRONT DOOR APT. #1	
202	2'-0"	6'-8"	1-1/2"		SOLID CORE INTERIOR WOOD DOOR	
203	2'-6"	6'-8"	1-1/2"		LOUVERED	
204	2'-8"	6'-8"	1-1/2"			
205	2'-6"	6'-8"	1-1/2"		LOUVERED	
206	2'-6"	6'-8"	1-1/2"			
207	3'-0"	6'-8"	1-3/4"		SOLID CORE INTERIOR WOOD DOOR FRONT DOOR APT. #2	
208	2'-0"	6'-8"	1-1/2"		SOLID CORE INTERIOR WOOD DOOR	
209	2'-6"	6'-8"	1-1/2"		LOUVERED	
210	2'-6"	6'-8"	1-1/2"			
211	3'-0"	6'-8"	1-3/4"		SOLID CORE INTERIOR WOOD DOOR FRONT DOOR APT. #3	
212	2'-6"	6'-8"	1-1/2"		SOLID CORE INTERIOR WOOD DOOR	
213	2'-0"	6'-8"	1-1/2"		LOUVERED	
214	2'-6"	6'-8"	1-1/2"			
215	3'-0"	6'-8"	1-3/4"		SOLID CORE INTERIOR WOOD DOOR FRONT DOOR APT. #4	
216	2'-0"	6'-8"	1-1/2"		SOLID CORE INTERIOR WOOD DOOR LOUVERED	
217	2'-0"	6'-8"	1-1/2"			
218	2'-6"	6'-8"	1-1/2"			
219	2'-6"	6'-8"	1-1/2"		LOUVERED	



SECOND FLOOR DOOR SCHEDULE					
NUMBER	NOMINAL SIZE			TYPE	MISCELLANEOUS NOTES
	WIDTH	HEIGHT	THICK.		
(200)	3'-0"	6'-8"	1-3/4"		SOLID CORE, EXISTING DOOR TO REMAIN
(201)	3'-0"	6'-8"	1-3/4"		SOLID CORE INTERIOR WOOD DOOR FRONT DOOR APT. #1
(202)	2'-0"	6'-8"	1-1/2"		SOLID CORE INTERIOR WOOD DOOR
(203)	2'-6"	6'-8"	1-1/2"		↓ LOUVERED
(204)	2'-8"	6'-8"	1-1/2"		
(205)	2'-6"	6'-8"	1-1/2"		↓ LOUVERED
(206)	2'-6"	6'-8"	1-1/2"		↓
(207)	3'-0"	6'-8"	1-3/4"		SOLID CORE INTERIOR WOOD DOOR FRONT DOOR APT. #2
(208)	2'-0"	6'-8"	1-1/2"		SOLID CORE INTERIOR WOOD DOOR
(209)	2'-6"	6'-8"	1-1/2"		↓
(210)	2'-6"	6'-8"	1-1/2"		↓ LOUVERED
(211)	3'-0"	6'-8"	1-3/4"		SOLID CORE INTERIOR WOOD DOOR FRONT DOOR APT. #3
(212)	2'-6"	6'-8"	1-1/2"		SOLID CORE INTERIOR WOOD DOOR
(213)	2'-0"	6'-8"	1-1/2"		↓
(214)	2'-6"	6'-8"	1-1/2"		↓ LOUVERED
(215)	3'-0"	6'-8"	1-3/4"		SOLID CORE INTERIOR WOOD DOOR FRONT DOOR APT. #4
(216)	2'-0"	6'-8"	1-1/2"		SOLID CORE INTERIOR WOOD DOOR LOUVERED
(217)	2'-0"	6'-8"	1-1/2"		↓
(218)	2'-6"	6'-8"	1-1/2"		
(219)	2'-6"	6'-8"	1-1/2"		↓ LOUVERED

ALL INTERIOR AND WOOD DOORS SHALL BE SIMPSON OR EQUAL.

The diagram illustrates two standard door elevations. Elevation A, labeled 'SOLID CORE', shows a door with a height of 6 feet 8 inches and a variable width. Elevation B, labeled 'LOUVERED', shows a door with the same height of 6 feet 8 inches but a fixed width of 2 feet 6 inches. The drawings include dimension lines and symbols corresponding to the door types listed in the schedule above.

DOOR ELEVATIONS

SCALE: 1/4" = 1'-0"

SECOND FLOOR DOOR SCHEDULE					
NUMBER	NOMINAL SIZE			TYPE	MISCELLANEOUS NOTES
	WIDTH	HEIGHT	THICK.		
(200)	3'-0"	6'-8"	1-3/4"		SOLID CORE, EXISTING DOOR TO REMAIN
(201)	3'-0"	6'-8"	1-3/4"		SOLID CORE INTERIOR WOOD DOOR FRONT DOOR APT. #1
(202)	2'-0"	6'-8"	1-1/2"		SOLID CORE INTERIOR WOOD DOOR
(203)	2'-6"	6'-8"	1-1/2"		↓ LOUVERED
(204)	2'-8"	6'-8"	1-1/2"		
(205)	2'-6"	6'-8"	1-1/2"		↓ LOUVERED
(206)	2'-6"	6'-8"	1-1/2"		↓
(207)	3'-0"	6'-8"	1-3/4"		SOLID CORE INTERIOR WOOD DOOR FRONT DOOR APT. #2
(208)	2'-0"	6'-8"	1-1/2"		SOLID CORE INTERIOR WOOD DOOR
(209)	2'-6"	6'-8"	1-1/2"		↓
(210)	2'-6"	6'-8"	1-1/2"		↓ LOUVERED
(211)	3'-0"	6'-8"	1-3/4"		SOLID CORE INTERIOR WOOD DOOR FRONT DOOR APT. #3
(212)	2'-6"	6'-8"	1-1/2"		SOLID CORE INTERIOR WOOD DOOR
(213)	2'-0"	6'-8"	1-1/2"		↓
(214)	2'-6"	6'-8"	1-1/2"		↓ LOUVERED
(215)	3'-0"	6'-8"	1-3/4"		SOLID CORE INTERIOR WOOD DOOR FRONT DOOR APT. #4
(216)	2'-0"	6'-8"	1-1/2"		SOLID CORE INTERIOR WOOD DOOR LOUVERED
(217)	2'-0"	6'-8"	1-1/2"		↓
(218)	2'-6"	6'-8"	1-1/2"		
(219)	2'-6"	6'-8"	1-1/2"		↓ LOUVERED

ALL INTERIOR AND WOOD DOORS SHALL BE SIMPSON OR EQUAL.

The diagram illustrates two door types: a solid core door (labeled A) and a louvered door (labeled B). Both have a standard height of 6 feet 8 inches. The solid core door's width varies, while the louvered door is specified at 2 feet 6 inches wide. The louvered door shows internal horizontal slats.

DOOR ELEVATIONS

SCALE: 1/4" = 1'-0"

APPLIANCES							
SYMBOL	ITEM	ROOM	MANUFACTURER/MODEL NO.	DIMENSIONS	COLOR	FAUCET/VALVES	MISCELLANEOUS NOTES
	REFRIGERATOR	APTS 1-4					
	DISHWASHER	APTS 1-4					
	COOKSTOVE/OVEN	APTS 1-4					WITH EXHAUST HOOD TO OUTDOORS
	HEAT PUMP ELECTRIC VOLUME WATER HEATER	APTS 1-4					ELECTRIC
	HEAT PUMP UNIT (INSIDE)	APTS 1-4					CASSETTE IN CEILING OUTDOOR CONDENSER ON ROOF
	HEAT PUMP IN BEDROOM	APT 1					WALL MOUNT UNIT CONNECT TO SAME OUTDOOR UNIT AS CASSETTE
	CLOTHES DRYER STACKABLE	APT 1					ELECTRIC

 
 
 
APPLIANCES							
SYMBOL	ITEM	ROOM	MANUFACTURER/MODEL NO.	DIMENSIONS	COLOR	FAUCET/VALVES	MISCELLANEOUS NOTES
	REFRIGERATOR	APTS 1-4					
	DISHWASHER	APTS 1-4					
	COOKSTOVE/OVEN	APTS 1-4					WITH EXHAUST HOOD TO OUTDOORS
	HEAT PUMP ELECTRIC VOLUME WATER HEATER	APTS 1-4					ELECTRIC
	HEAT PUMP UNIT (INSIDE)	APTS 1-4					CASSETTE IN CEILING OUTDOOR CONDENSER ON ROOF
	HEAT PUMP IN BEDROOM	APT 1					WALL MOUNT UNIT CONNECT TO SAME OUTDOOR UNIT AS CASSETTE
	CLOTHES DRYER STACKABLE	APT 1					ELECTRIC

FINISH SCHEDULE								
ROOM NAME	FLOOR	BASE	WALLS		CEILINGS			REMARKS
			MATERIAL	FINISH	MATERIAL	FINISH	PL. HT.	
APARTMENTS 1-4	VINYL	WOOD	1/2" GYP. BD.	MEDITERRANEAN	5/8" GYP. BD.	MEDITERRANEAN	8'-6"	
REFER TO SHEET FST1 FOR ROOM FINISH SCHEDULE FOR GROUND FLOOR AREAS								

 
 
 
FINISH SCHEDULE								
ROOM NAME	FLOOR	BASE	WALLS		CEILINGS			REMARKS
			MATERIAL	FINISH	MATERIAL	FINISH	PL. HT.	
APARTMENTS 1-4	VINYL	WOOD	1/2" GYP. BD.	MEDITERRANEAN	5/8" GYP. BD.	MEDITERRANEAN	8'-6"	
REFER TO SHEET FST1 FOR ROOM FINISH SCHEDULE FOR GROUND FLOOR AREAS								

FINISH SCHEDULE								
ROOM NAME	FLOOR	BASE	WALLS		CEILINGS			REMARKS
			MATERIAL	FINISH	MATERIAL	FINISH	PL. HT.	
APARTMENTS 1-4	VINYL	WOOD	1/2" GYP. BD.	MEDITERRANEAN	5/8" GYP. BD.	MEDITERRANEAN	8'-6"	
REFER TO SHEET FST1 FOR ROOM FINISH SCHEDULE FOR GROUND FLOOR AREAS								

 
 
LEGEND TO SYMBOLS:

DRAWING TITLE		
DRAWING SCALE		
		SECTION CUT DRAWING NUMBER
=====	=====	SHEET NUMBER
		DETAIL DRAWING NUMBER
		SHEET NUMBER
		DOOR NUMBER, SEE SCHEDULES, SHT A5
		WINDOW NUMBER
		PLUMBING FIXTURE CALL OUT
		APPLIANCE CALL OUT
		ELEVATION OF FINISHED GRADE ($\pm 0"$ IS INTERIOR FINISH FLOOR FOR REFERENCE)
=====		(E) WALL TO REMAIN
=====		(E) WALL TO BE REMOVED
		(N) WALL 2x6 (2x4) W/ 1/2" GYP BD. EA SIDE
		FLOOR SINK, SEE FOOD SERVICE EQUIPMENT DRAWINGS FOR KITCHEN AREA DETAILS

 
 
 
LEGEND TO SYMBOLS:

DRAWING TITLE	
DRAWING SCALE	
	 SECTION CUT DRAWING NUMBER SHEET NUMBER
	
	DETAIL DRAWING NUMBER SHEET NUMBER
	DOOR NUMBER, SEE SCHEDULES, SHT A5
	WINDOW NUMBER
	PLUMBING FIXTURE CALL OUT
	APPLIANCE CALL OUT
	ELEVATION OF FINISHED GRADE ($\pm 0"$ IS INTERIOR FINISH FLOOR FOR REFERENCE)
	(E) WALL TO REMAIN
	(E) WALL TO BE REMOVED
	(N) WALL 2x6 (2x4) W/ 1/2" GYP BD. EA SIDE
	FLOOR SINK, SEE FOOD SERVICE EQUIPMENT DRAWINGS FOR KITCHEN AREA DETAILS

 
 
LEGEND TO SYMBOLS:

DRAWING TITLE		
DRAWING SCALE		
		<u>SECTION CUT DRAWING NUMBER</u>
		<u>SHEET NUMBER</u>
		<u>DETAIL DRAWING NUMBER</u>
		<u>SHEET NUMBER</u>
		DOOR NUMBER, SEE SCHEDULES, SHT A5
		WINDOW NUMBER
		PLUMBING FIXTURE CALL OUT
		APPLIANCE CALL OUT
		ELEVATION OF FINISHED GRADE ($\pm 0"$ IS INTERIOR FINISH FLOOR FOR REFERENCE)
		(E) WALL TO REMAIN
		(E) WALL TO BE REMOVED
		(N) WALL 2x6 (2x4) W/ 1/2" GYP BD. EA SIDE
		FLOOR SINK, SEE FOOD SERVICE EQUIPMENT DRAWINGS FOR KITCHEN AREA DETAILS

 
 
 
LEGEND TO SYMBOLS:

DRAWING TITLE		
DRAWING SCALE		
		SECTION CUT DRAWING NUMBER
=====	=====	SHEET NUMBER
		DETAIL DRAWING NUMBER
		SHEET NUMBER
		DOOR NUMBER, SEE SCHEDULES, SHT A5
		WINDOW NUMBER
		PLUMBING FIXTURE CALL OUT
		APPLIANCE CALL OUT
		ELEVATION OF FINISHED GRADE ($\pm 0"$ IS INTERIOR FINISH FLOOR FOR REFERENCE)
=====		(E) WALL TO REMAIN
=====		(E) WALL TO BE REMOVED
		(N) WALL 2x6 (2x4) W/ 1/2" GYP BD. EA SIDE
		FLOOR SINK, SEE FOOD SERVICE EQUIPMENT DRAWINGS FOR KITCHEN AREA DETAILS

 
 
 
LEGEND TO SYMBOLS:

DRAWING TITLE		
DRAWING SCALE		
		<u>SECTION CUT DRAWING NUMBER</u>
		<u>SHEET NUMBER</u>
		<u>DETAIL DRAWING NUMBER</u>
		<u>SHEET NUMBER</u>
		DOOR NUMBER, SEE SCHEDULES, SHT A5
		WINDOW NUMBER
		PLUMBING FIXTURE CALL OUT
		APPLIANCE CALL OUT
		ELEVATION OF FINISHED GRADE ($\pm 0"$ IS INTERIOR FINISH FLOOR FOR REFERENCE)
		(E) WALL TO REMAIN
		(E) WALL TO BE REMOVED
		(N) WALL 2x6 (2x4) W/ 1/2" GYP BD. EA SIDE
		FLOOR SINK, SEE FOOD SERVICE EQUIPMENT DRAWINGS FOR KITCHEN AREA DETAILS

 
 
 
LEGEND TO SYMBOLS:

DRAWING TITLE	
DRAWING SCALE	
	 SECTION CUT DRAWING NUMBER SHEET NUMBER
	
	DETAIL DRAWING NUMBER SHEET NUMBER
	DOOR NUMBER, SEE SCHEDULES, SHT A5
	WINDOW NUMBER
	PLUMBING FIXTURE CALL OUT
	APPLIANCE CALL OUT
	ELEVATION OF FINISHED GRADE ($\pm 0"$ IS INTERIOR FINISH FLOOR FOR REFERENCE)
	(E) WALL TO REMAIN
	(E) WALL TO BE REMOVED
	(N) WALL 2x6 (2x4) W/ 1/2" GYP BD. EA SIDE
	FLOOR SINK, SEE FOOD SERVICE EQUIPMENT DRAWINGS FOR KITCHEN AREA DETAILS

 
 
 
LEGEND TO SYMBOLS:

DRAWING TITLE	
DRAWING SCALE	
	 SECTION CUT DRAWING NUMBER SHEET NUMBER
	
	DETAIL DRAWING NUMBER SHEET NUMBER
	DOOR NUMBER, SEE SCHEDULES, SHT A5
	WINDOW NUMBER
	PLUMBING FIXTURE CALL OUT
	APPLIANCE CALL OUT
	ELEVATION OF FINISHED GRADE ($\pm 0"$ IS INTERIOR FINISH FLOOR FOR REFERENCE)
	(E) WALL TO REMAIN
	(E) WALL TO BE REMOVED
	(N) WALL 2x6 (2x4) W/ 1/2" GYP BD. EA SIDE
	FLOOR SINK, SEE FOOD SERVICE EQUIPMENT DRAWINGS FOR KITCHEN AREA DETAILS

 
 
 
LEGEND TO SYMBOLS:

DRAWING TITLE	
DRAWING SCALE	
	 SECTION CUT DRAWING NUMBER SHEET NUMBER
	
	DETAIL DRAWING NUMBER SHEET NUMBER
	DOOR NUMBER, SEE SCHEDULES, SHT A5
	WINDOW NUMBER
	PLUMBING FIXTURE CALL OUT
	APPLIANCE CALL OUT
	ELEVATION OF FINISHED GRADE ($\pm 0"$ IS INTERIOR FINISH FLOOR FOR REFERENCE)
	(E) WALL TO REMAIN
	(E) WALL TO BE REMOVED
	(N) WALL 2x6 (2x4) W/ 1/2" GYP BD. EA SIDE
	FLOOR SINK, SEE FOOD SERVICE EQUIPMENT DRAWINGS FOR KITCHEN AREA DETAILS

 
 
 
LEGEND TO SYMBOLS:

DRAWING TITLE	
DRAWING SCALE	
	 SECTION CUT DRAWING NUMBER SHEET NUMBER
	
	DETAIL DRAWING NUMBER SHEET NUMBER
	DOOR NUMBER, SEE SCHEDULES, SHT A5
	WINDOW NUMBER
	PLUMBING FIXTURE CALL OUT
	APPLIANCE CALL OUT
	ELEVATION OF FINISHED GRADE ($\pm 0"$ IS INTERIOR FINISH FLOOR FOR REFERENCE)
	(E) WALL TO REMAIN
	(E) WALL TO BE REMOVED
	(N) WALL 2x6 (2x4) W/ 1/2" GYP BD. EA SIDE
	FLOOR SINK, SEE FOOD SERVICE EQUIPMENT DRAWINGS FOR KITCHEN AREA DETAILS

 
 
 
LEGEND TO SYMBOLS:

DRAWING TITLE	
DRAWING SCALE	
	 SECTION CUT DRAWING NUMBER SHEET NUMBER
	
	DETAIL DRAWING NUMBER SHEET NUMBER
	DOOR NUMBER, SEE SCHEDULES, SHT A5
	WINDOW NUMBER
	PLUMBING FIXTURE CALL OUT
	APPLIANCE CALL OUT
	ELEVATION OF FINISHED GRADE ($\pm 0"$ IS INTERIOR FINISH FLOOR FOR REFERENCE)
	(E) WALL TO REMAIN
	(E) WALL TO BE REMOVED
	(N) WALL 2x6 (2x4) W/ 1/2" GYP BD. EA SIDE
	FLOOR SINK, SEE FOOD SERVICE EQUIPMENT DRAWINGS FOR KITCHEN AREA DETAILS

 
 
 
LEGEND TO SYMBOLS:

DRAWING TITLE	
DRAWING SCALE	
	 SECTION CUT DRAWING NUMBER SHEET NUMBER
	
	DETAIL DRAWING NUMBER SHEET NUMBER
	DOOR NUMBER, SEE SCHEDULES, SHT A5
	WINDOW NUMBER
	PLUMBING FIXTURE CALL OUT
	APPLIANCE CALL OUT
	ELEVATION OF FINISHED GRADE ($\pm 0"$ IS INTERIOR FINISH FLOOR FOR REFERENCE)
	(E) WALL TO REMAIN
	(E) WALL TO BE REMOVED
	(N) WALL 2x6 (2x4) W/ 1/2" GYP BD. EA SIDE
	FLOOR SINK, SEE FOOD SERVICE EQUIPMENT DRAWINGS FOR KITCHEN AREA DETAILS

 
 
 
LEGEND TO SYMBOLS:

DRAWING TITLE	
DRAWING SCALE	
	 SECTION CUT DRAWING NUMBER SHEET NUMBER
	
	DETAIL DRAWING NUMBER SHEET NUMBER
	DOOR NUMBER, SEE SCHEDULES, SHT A5
	WINDOW NUMBER
	PLUMBING FIXTURE CALL OUT
	APPLIANCE CALL OUT
	ELEVATION OF FINISHED GRADE ($\pm 0"$ IS INTERIOR FINISH FLOOR FOR REFERENCE)
	(E) WALL TO REMAIN
	(E) WALL TO BE REMOVED
	(N) WALL 2x6 (2x4) W/ 1/2" GYP BD. EA SIDE
	FLOOR SINK, SEE FOOD SERVICE EQUIPMENT DRAWINGS FOR KITCHEN AREA DETAILS

 
 
 
LEGEND TO SYMBOLS:

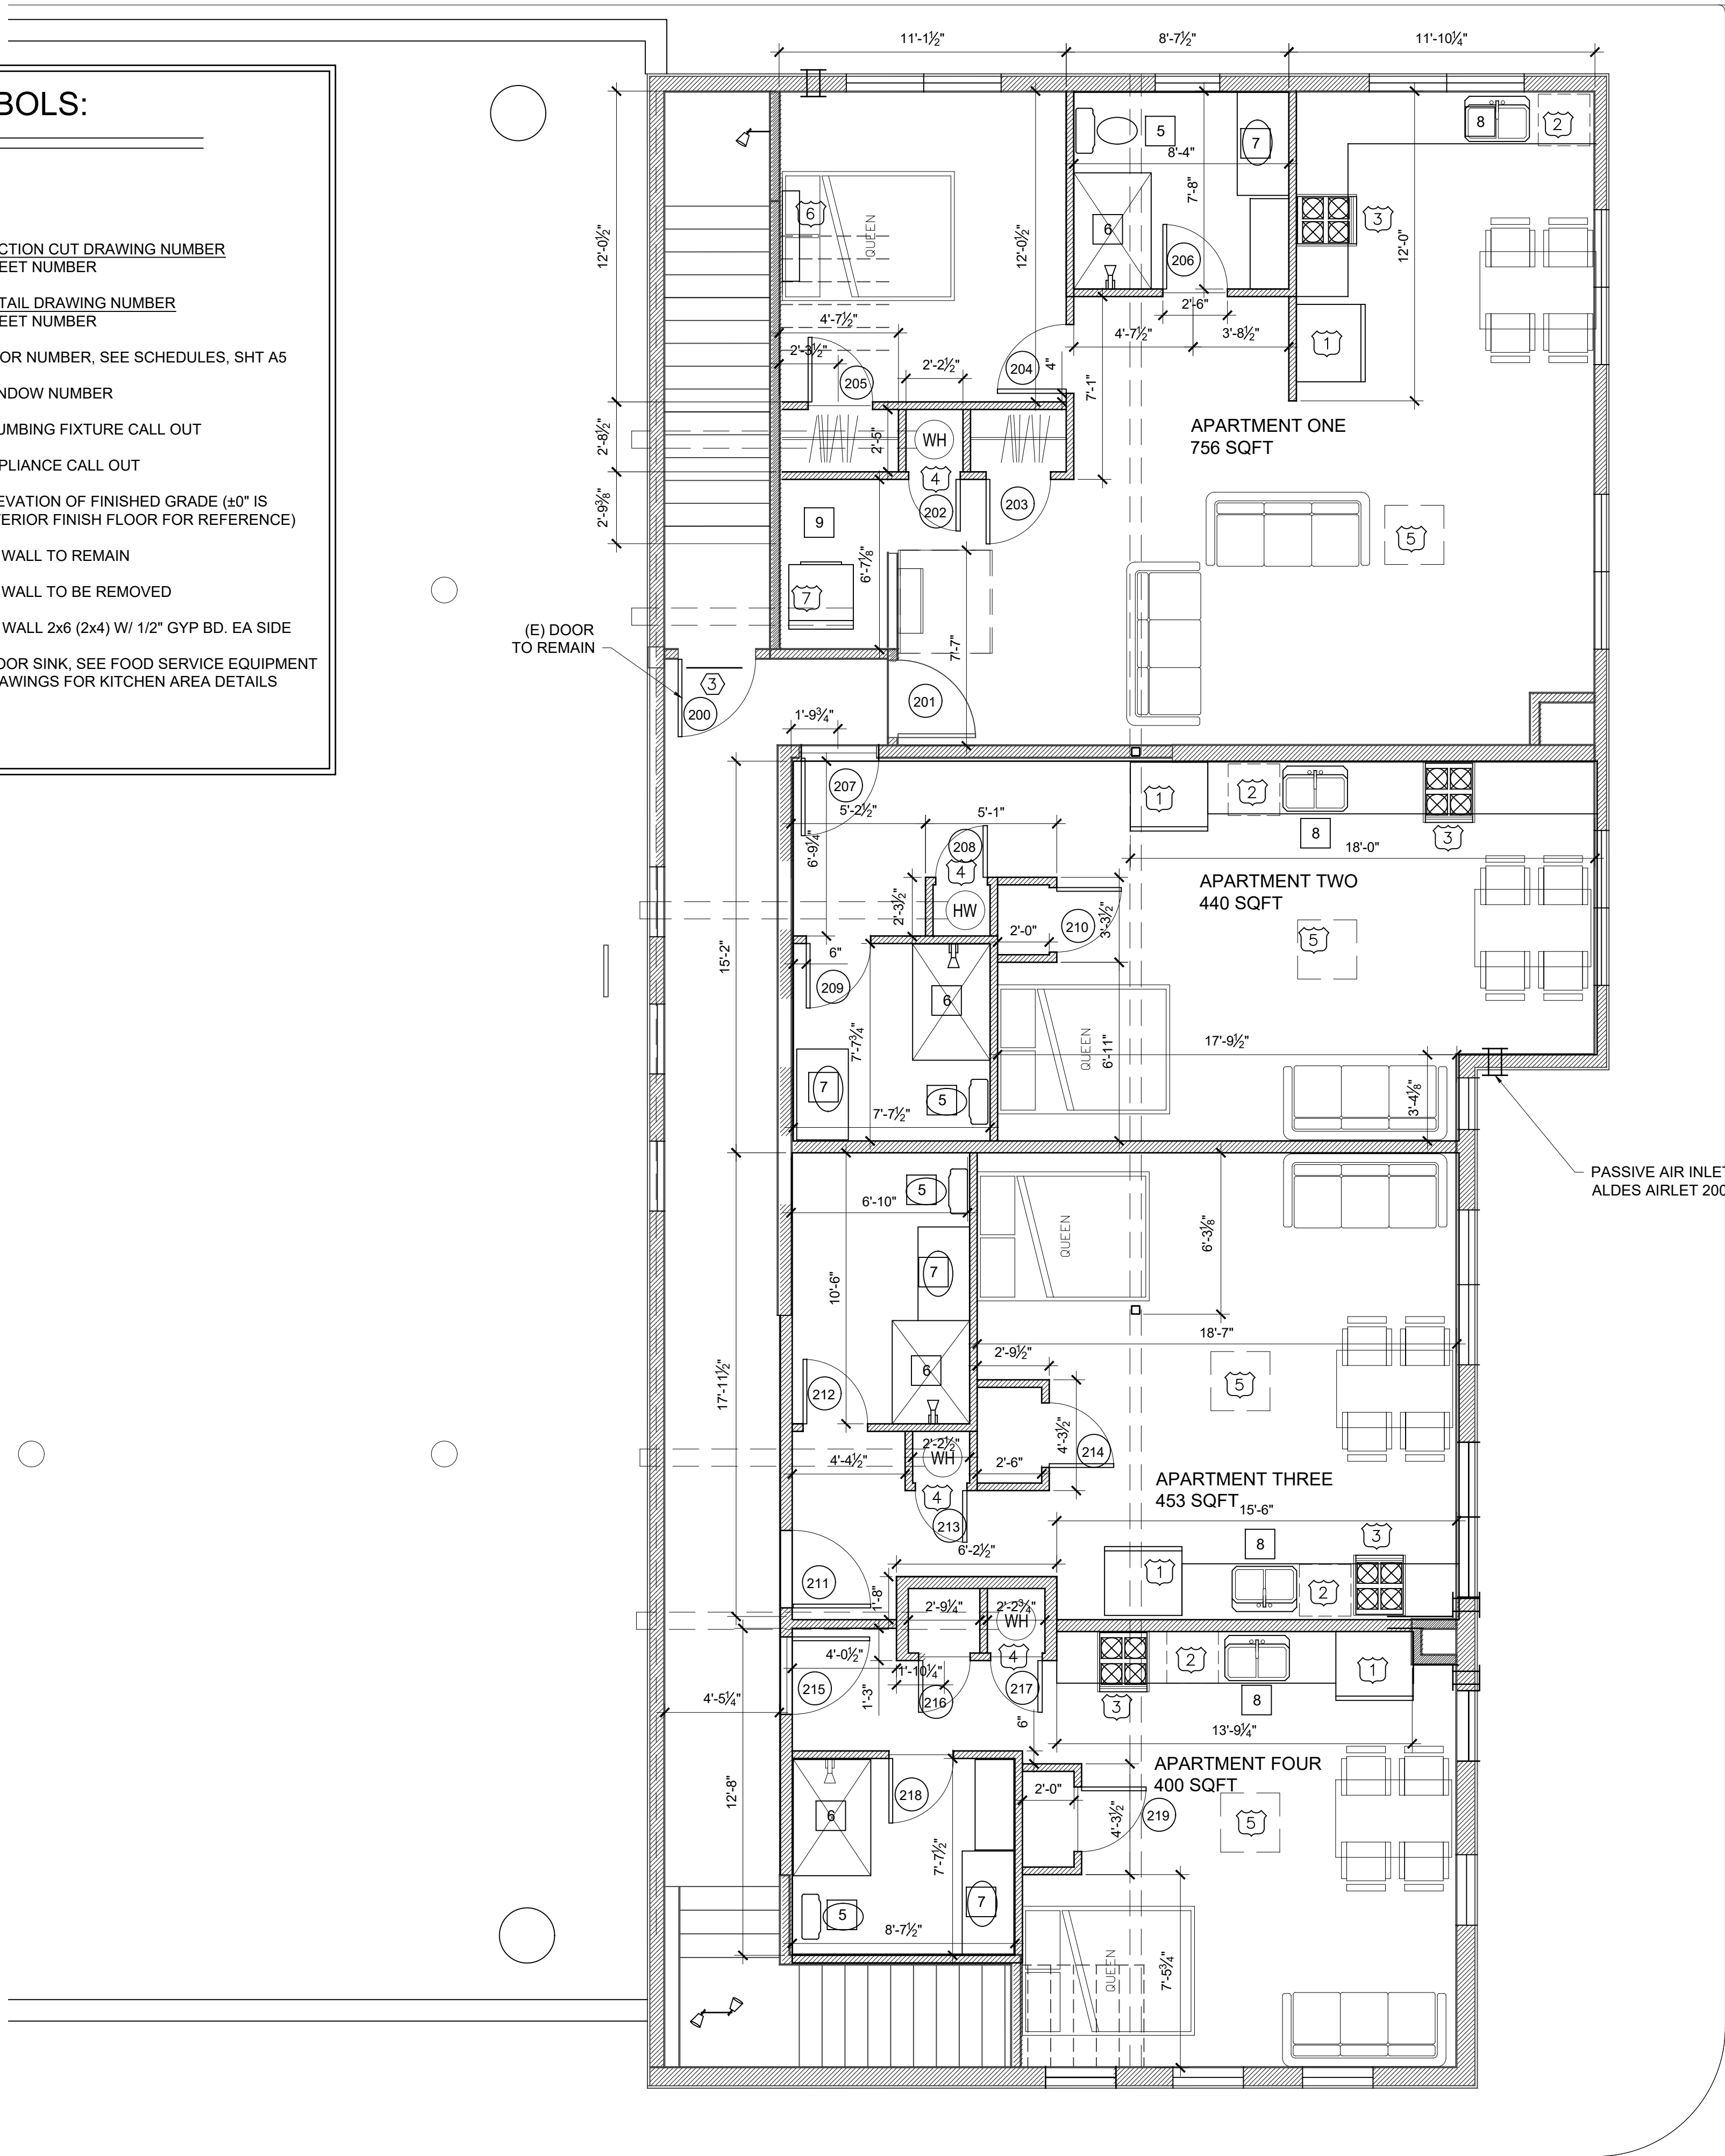
DRAWING TITLE	
DRAWING SCALE	
	 SECTION CUT DRAWING NUMBER SHEET NUMBER
	
	DETAIL DRAWING NUMBER SHEET NUMBER
	DOOR NUMBER, SEE SCHEDULES, SHT A5
	WINDOW NUMBER
	PLUMBING FIXTURE CALL OUT
	APPLIANCE CALL OUT
	ELEVATION OF FINISHED GRADE ($\pm 0"$ IS INTERIOR FINISH FLOOR FOR REFERENCE)
	(E) WALL TO REMAIN
	(E) WALL TO BE REMOVED
	(N) WALL 2x6 (2x4) W/ 1/2" GYP BD. EA SIDE
	FLOOR SINK, SEE FOOD SERVICE EQUIPMENT DRAWINGS FOR KITCHEN AREA DETAILS

LEGEND TO SYMBOLS:

DRAWING TITLE	
DRAWING SCALE	
	 SECTION CUT DRAWING NUMBER SHEET NUMBER
	
	DETAIL DRAWING NUMBER SHEET NUMBER
	DOOR NUMBER, SEE SCHEDULES, SHT A5
	WINDOW NUMBER
	PLUMBING FIXTURE CALL OUT
	APPLIANCE CALL OUT
	ELEVATION OF FINISHED GRADE ($\pm 0"$ IS INTERIOR FINISH FLOOR FOR REFERENCE)
	(E) WALL TO REMAIN
	(E) WALL TO BE REMOVED
	(N) WALL 2x6 (2x4) W/ 1/2" GYP BD. EA SIDE
	FLOOR SINK, SEE FOOD SERVICE EQUIPMENT DRAWINGS FOR KITCHEN AREA DETAILS

LEGEND TO SYMBOLS:

DRAWING TITLE	
DRAWING SCALE	
	 SECTION CUT DRAWING NUMBER SHEET NUMBER
	
	DETAIL DRAWING NUMBER SHEET NUMBER
	DOOR NUMBER, SEE SCHEDULES, SHT A5
	WINDOW NUMBER
	PLUMBING FIXTURE CALL OUT
	APPLIANCE CALL OUT
	ELEVATION OF FINISHED GRADE ($\pm 0"$ IS INTERIOR FINISH FLOOR FOR REFERENCE)
	(E) WALL TO REMAIN
	(E) WALL TO BE REMOVED
	(N) WALL 2x6 (2x4) W/ 1/2" GYP BD. EA SIDE
	FLOOR SINK, SEE FOOD SERVICE EQUIPMENT DRAWINGS FOR KITCHEN AREA DETAILS



BOLTS:

SECTION CUT DRAWING NUMBER
SHEET NUMBER

DETAIL DRAWING NUMBER
SHEET NUMBER

FOR NUMBER, SEE SCHEDULES, SHT A5

WINDOW NUMBER

DUMBING FIXTURE CALL OUT

PLIANCE CALL OUT

ELEVATION OF FINISHED GRADE (40" IS
PRIOR FINISH FLOOR FOR REFERENCE)

WALL TO REMAIN

WALL TO BE REMOVED

DOOR SINK, SEE FOOD SERVICE EQUIPMENT
DRAWINGS FOR KITCHEN AREA DETAILS

APARTMENT ONE
756 SQFT

APARTMENT TWO
440 SQFT

APARTMENT THREE
453 SQFT

APARTMENT FOUR
400 SQFT

(E) DOOR
TO REMAIN

PASSIVE AIR INLET
ALDES AIRLET 200

Kelly B. Grimes, Architect

P.O. Box 598
Little River, CA 95456
707-937-2904

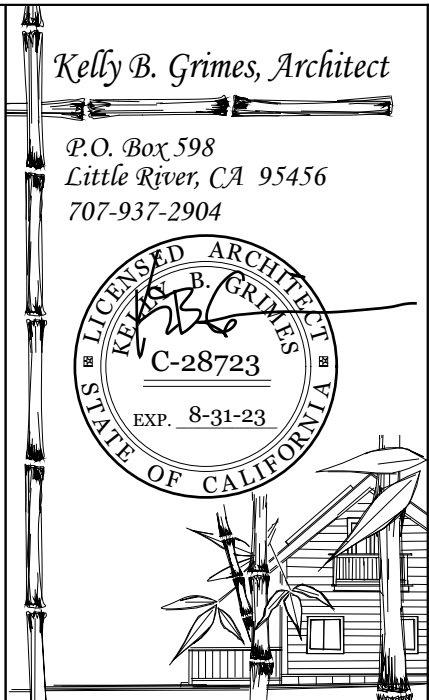
ARCHITECT
K. B. GRIMES
C-28723
EXP. 8-31-23
STATE OF CALIFORNIA

A stylized line drawing of a two-story house with a gabled roof and a palm tree in the foreground. The drawing is located in the bottom right corner of the page.

Kelly B. Grimes, Architect

P.O. Box 598
Little River, CA 95456
707-937-2904

ARCHITECT
K. B. GRIMES
C-28723
EXP. 8-31-23
STATE OF CALIFORNIA

A stylized line drawing of a two-story house with a gabled roof and a palm tree in the foreground. The drawing is located in the bottom right corner of the page.[illegible]

REVISIONS	BY

REMODELING PLANS FOR:	
PAPA BEAR'S PIZZA	
228 N. MAIN ST. FORT BRAGG, CA 95437	
A.P. #119-090-13	
DATE:	MARCH 20, 2023
SCALE:	AS NOTED
DRAWN BY:	KBG
JOB:	POOS
SHEET:	
ENLARGED UPPER FLOOR PLAN	
A2.2	
OF 1 SHEETS	

REMODELING PLANS FOR:	
PAPA BEAR'S PIZZA	
228 N. MAIN ST. FORT BRAGG, CA 95437	
A.P. #119-090-13	
DATE:	MARCH 20, 2023
SCALE:	AS NOTED
DRAWN BY:	KBG
JOB:	POOS
SHEET:	
ENLARGED UPPER FLOOR PLAN	
A2.2	
OF 1 SHEETS	

REMODELING PLANS FOR:	
PAPA BEAR'S PIZZA	
228 N. MAIN ST. FORT BRAGG, CA 95437	
A.P. #119-090-13	
DATE:	MARCH 20, 2023
SCALE:	AS NOTED
DRAWN BY:	KBG
JOB:	POOS
SHEET:	
ENLARGED UPPER FLOOR PLAN	
A2.2	
OF 1 SHEETS	

REMODELING PLANS FOR:	
PAPA BEAR'S PIZZA	
228 N. MAIN ST. FORT BRAGG, CA 95437	
A.P. #119-090-13	
DATE:	MARCH 20, 2023
SCALE:	AS NOTED
DRAWN BY:	KBG
JOB:	POOS
SHEET:	
ENLARGED UPPER FLOOR PLAN	
A2.2	
OF 1 SHEETS	

REMODELING PLANS FOR:	
PAPA BEAR'S PIZZA	
228 N. MAIN ST. FORT BRAGG, CA 95437	
A.P. #119-090-13	
DATE:	MARCH 20, 2023
SCALE:	AS NOTED
DRAWN BY:	KBG
JOB:	POOS
SHEET:	
ENLARGED UPPER FLOOR PLAN	
A2.2	
OF 1 SHEETS	

REMODELING PLANS FOR:	
PAPA BEAR'S PIZZA	
228 N. MAIN ST. FORT BRAGG, CA 95437	
A.P. #119-090-13	
DATE:	MARCH 20, 2023
SCALE:	AS NOTED
DRAWN BY:	KBG
JOB:	POOS
SHEET:	
ENLARGED UPPER FLOOR PLAN	
A2.2	
OF 1 SHEETS	

REMODELING PLANS FOR:	
PAPA BEAR'S PIZZA	
228 N. MAIN ST. FORT BRAGG, CA 95437	
A.P. #119-090-13	
DATE:	MARCH 20, 2023
SCALE:	AS NOTED
DRAWN BY:	KBG
JOB:	POOS
SHEET:	
ENLARGED UPPER FLOOR PLAN	
A2.2	
OF 1 SHEETS	

REMODELING PLANS FOR:	
PAPA BEAR'S PIZZA	
228 N. MAIN ST. FORT BRAGG, CA 95437	
A.P. #119-090-13	
DATE:	MARCH 20, 2023
SCALE:	AS NOTED
DRAWN BY:	KBG
JOB:	POOS
SHEET:	
ENLARGED UPPER FLOOR PLAN	
A2.2	
OF 1 SHEETS	

REMODELING PLANS FOR:	
PAPA BEAR'S PIZZA	
228 N. MAIN ST. FORT BRAGG, CA 95437	
A.P. #119-090-13	
DATE:	MARCH 20, 2023
SCALE:	AS NOTED
DRAWN BY:	KBG
JOB:	POOS
SHEET:	
ENLARGED UPPER FLOOR PLAN	
A2.2	
OF 1 SHEETS	

REMODELING PLANS FOR:	
PAPA BEAR'S PIZZA	
228 N. MAIN ST. FORT BRAGG, CA 95437	
A.P. #119-090-13	
DATE:	MARCH 20, 2023
SCALE:	AS NOTED
DRAWN BY:	KBG
JOB:	POOS
SHEET:	
ENLARGED UPPER FLOOR PLAN	
A2.2	
OF SHEETS	