



GROCERY OUTLET

Proposed Lighting Layout

SHEET L01 : LIGHTING SCHEDULE

SHEET L02 : PHOTOTMETRIC STUDY

SHEET L03 : SUMMARY PAGE



Head Office
400 S. Record St.
Dallas, TX 75202

Facade and Site Lighting Layout

GROCERY OUTLET
Fort Brags, CA

SHEET

CLIENT

ADDRESS


DESIGNER: CR

DATE: 05.03.2022

REV: 1

SCALE: 1" = 19'

L01

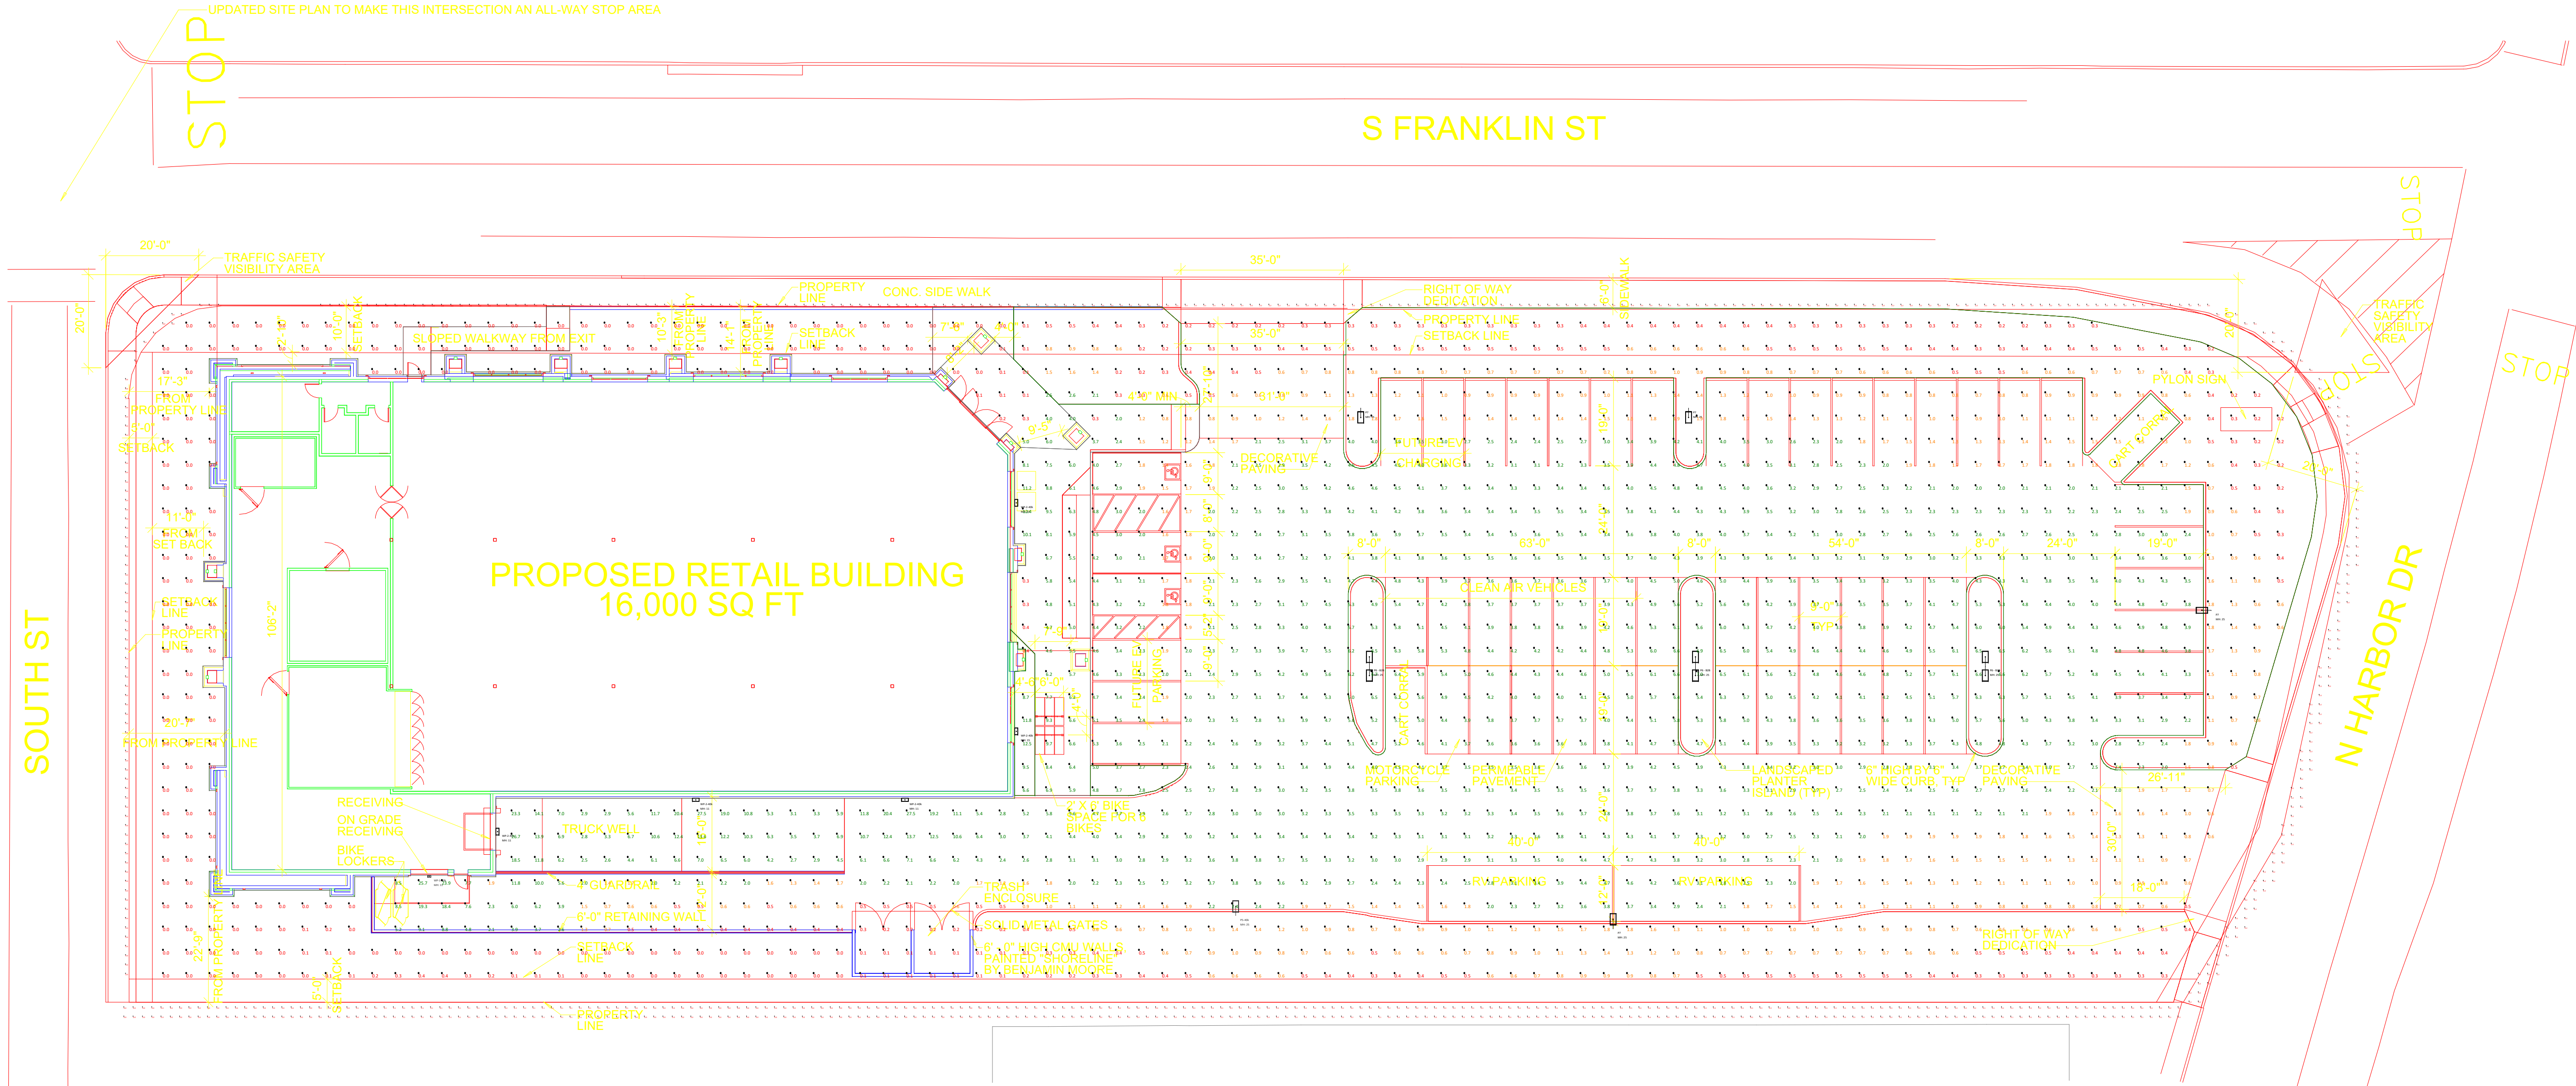

FIXTURE SCHEDULE

Luminaire Schedule								
Qty	Symbol	Label	Arrangement	Description	Lum. Watts	Total Watts	Lum. Lumens	LLF
1		P5-40k	SINGLE	Area Lighter / Acuity / RSX2 LED P1 40K R3 MVOLT RPA HS NLTAIR2 PIRHN DDBXD	72.0642	72.064	8107	0.900
3		P6 - B2B	Back-Back	Area Lighter / Acuity / RSX2 LED P1 40K R4	72.06	432.36	11135	0.900
4		P7	SINGLE	Area Lighter / Acuity / RSX2 LED P1 40K R4 HS	72.0642	288.257	7753	0.900
1		WP-1-40k	SINGLE	Wallpack / Acuity / WDGE2 LED P4 40K 80CRI VW MVOLT SRM DDBXD	34.96	34.96	4528	0.900
5		WP-2-40k	SINGLE	Wallpack / Acuity / WDGE3 LED P2 40K 80CRI R3 MVOLT SRM NLTAIR2PIR DDBXD	59.2761	296.381	8519	0.900



Head Office
400 S. Record St.
Dallas, TX 75202


Facade and Site Lighting Layout

GROCERY OUTLET
Fort Brags, CA

SHEET
CLIENT
ADDRESS

DESIGNER: CR
DATE: 05.03.2022
REV: 1
SCALE: 1" = 19'


L02

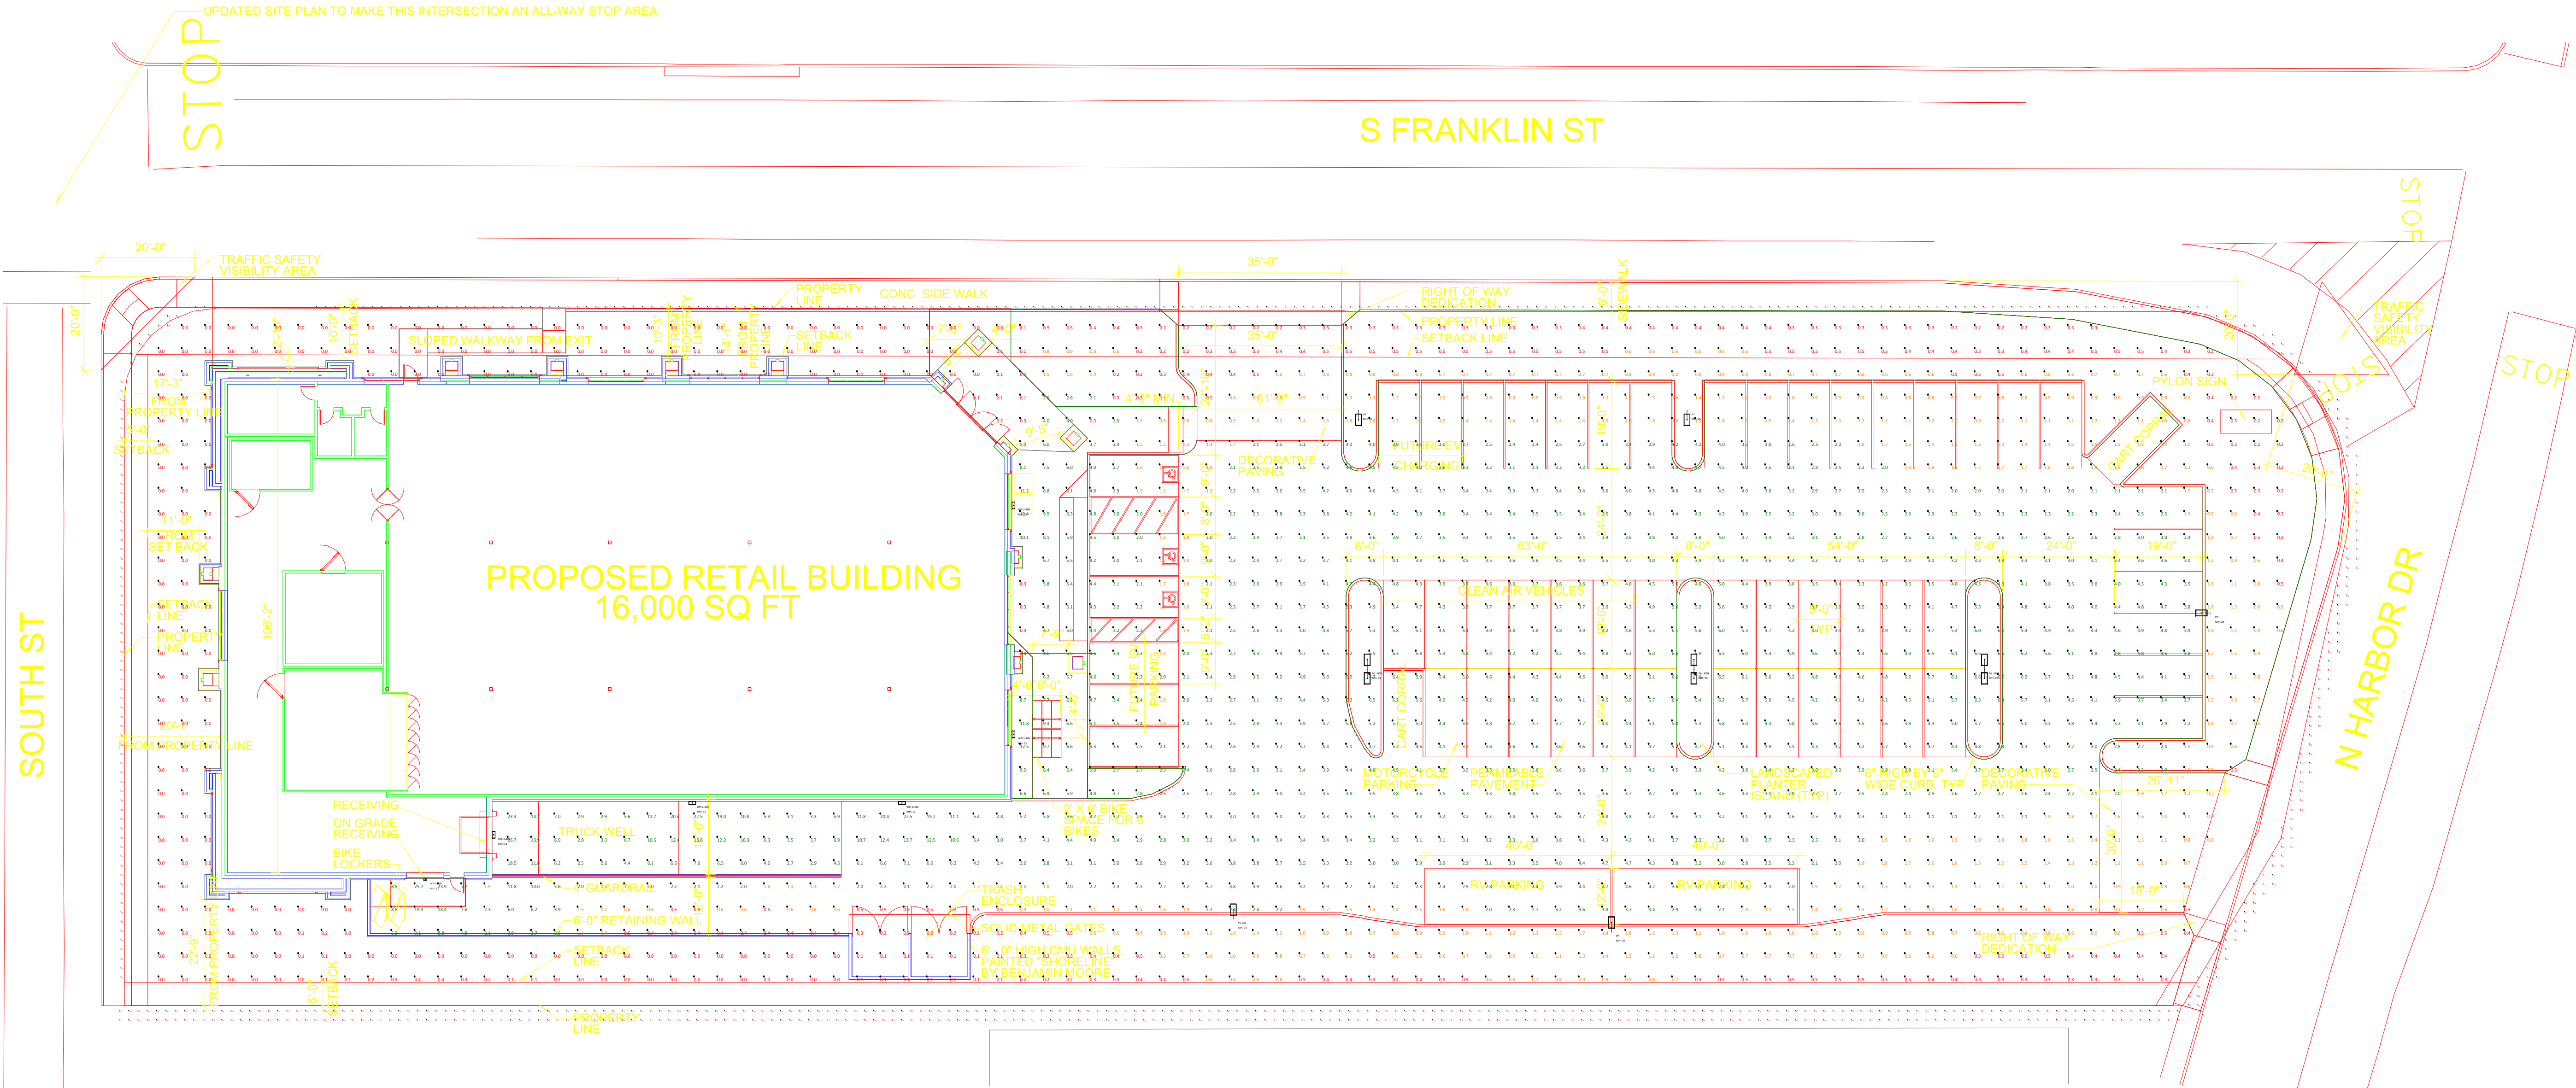


STATISTICAL SUMMARY

LPD Area Summary			
Label	Area	Total Watts	LPD
GO Fort Braggs CA	80083	1124.022	0.014


Calculation Summary									
Label	CalcType	Units	Avg	Max	Min	Avg/Min	Max/Min		
Parking Lot	Illuminance	Fc	3.13	7.0	0.5	6.26	14.00		
Plan East Entrance	Illuminance	Fc	1.18	2.4	0.5	2.36	4.80		
Plan North Entrance	Illuminance	Fc	0.94	4.0	0.2	4.70	20.00		
Property Line	Illuminance	Fc	0.14	0.5	0.0	N.A.	N.A.		
Truck Well	Illuminance	Fc	9.12	27.5	2.4	3.80	11.46		

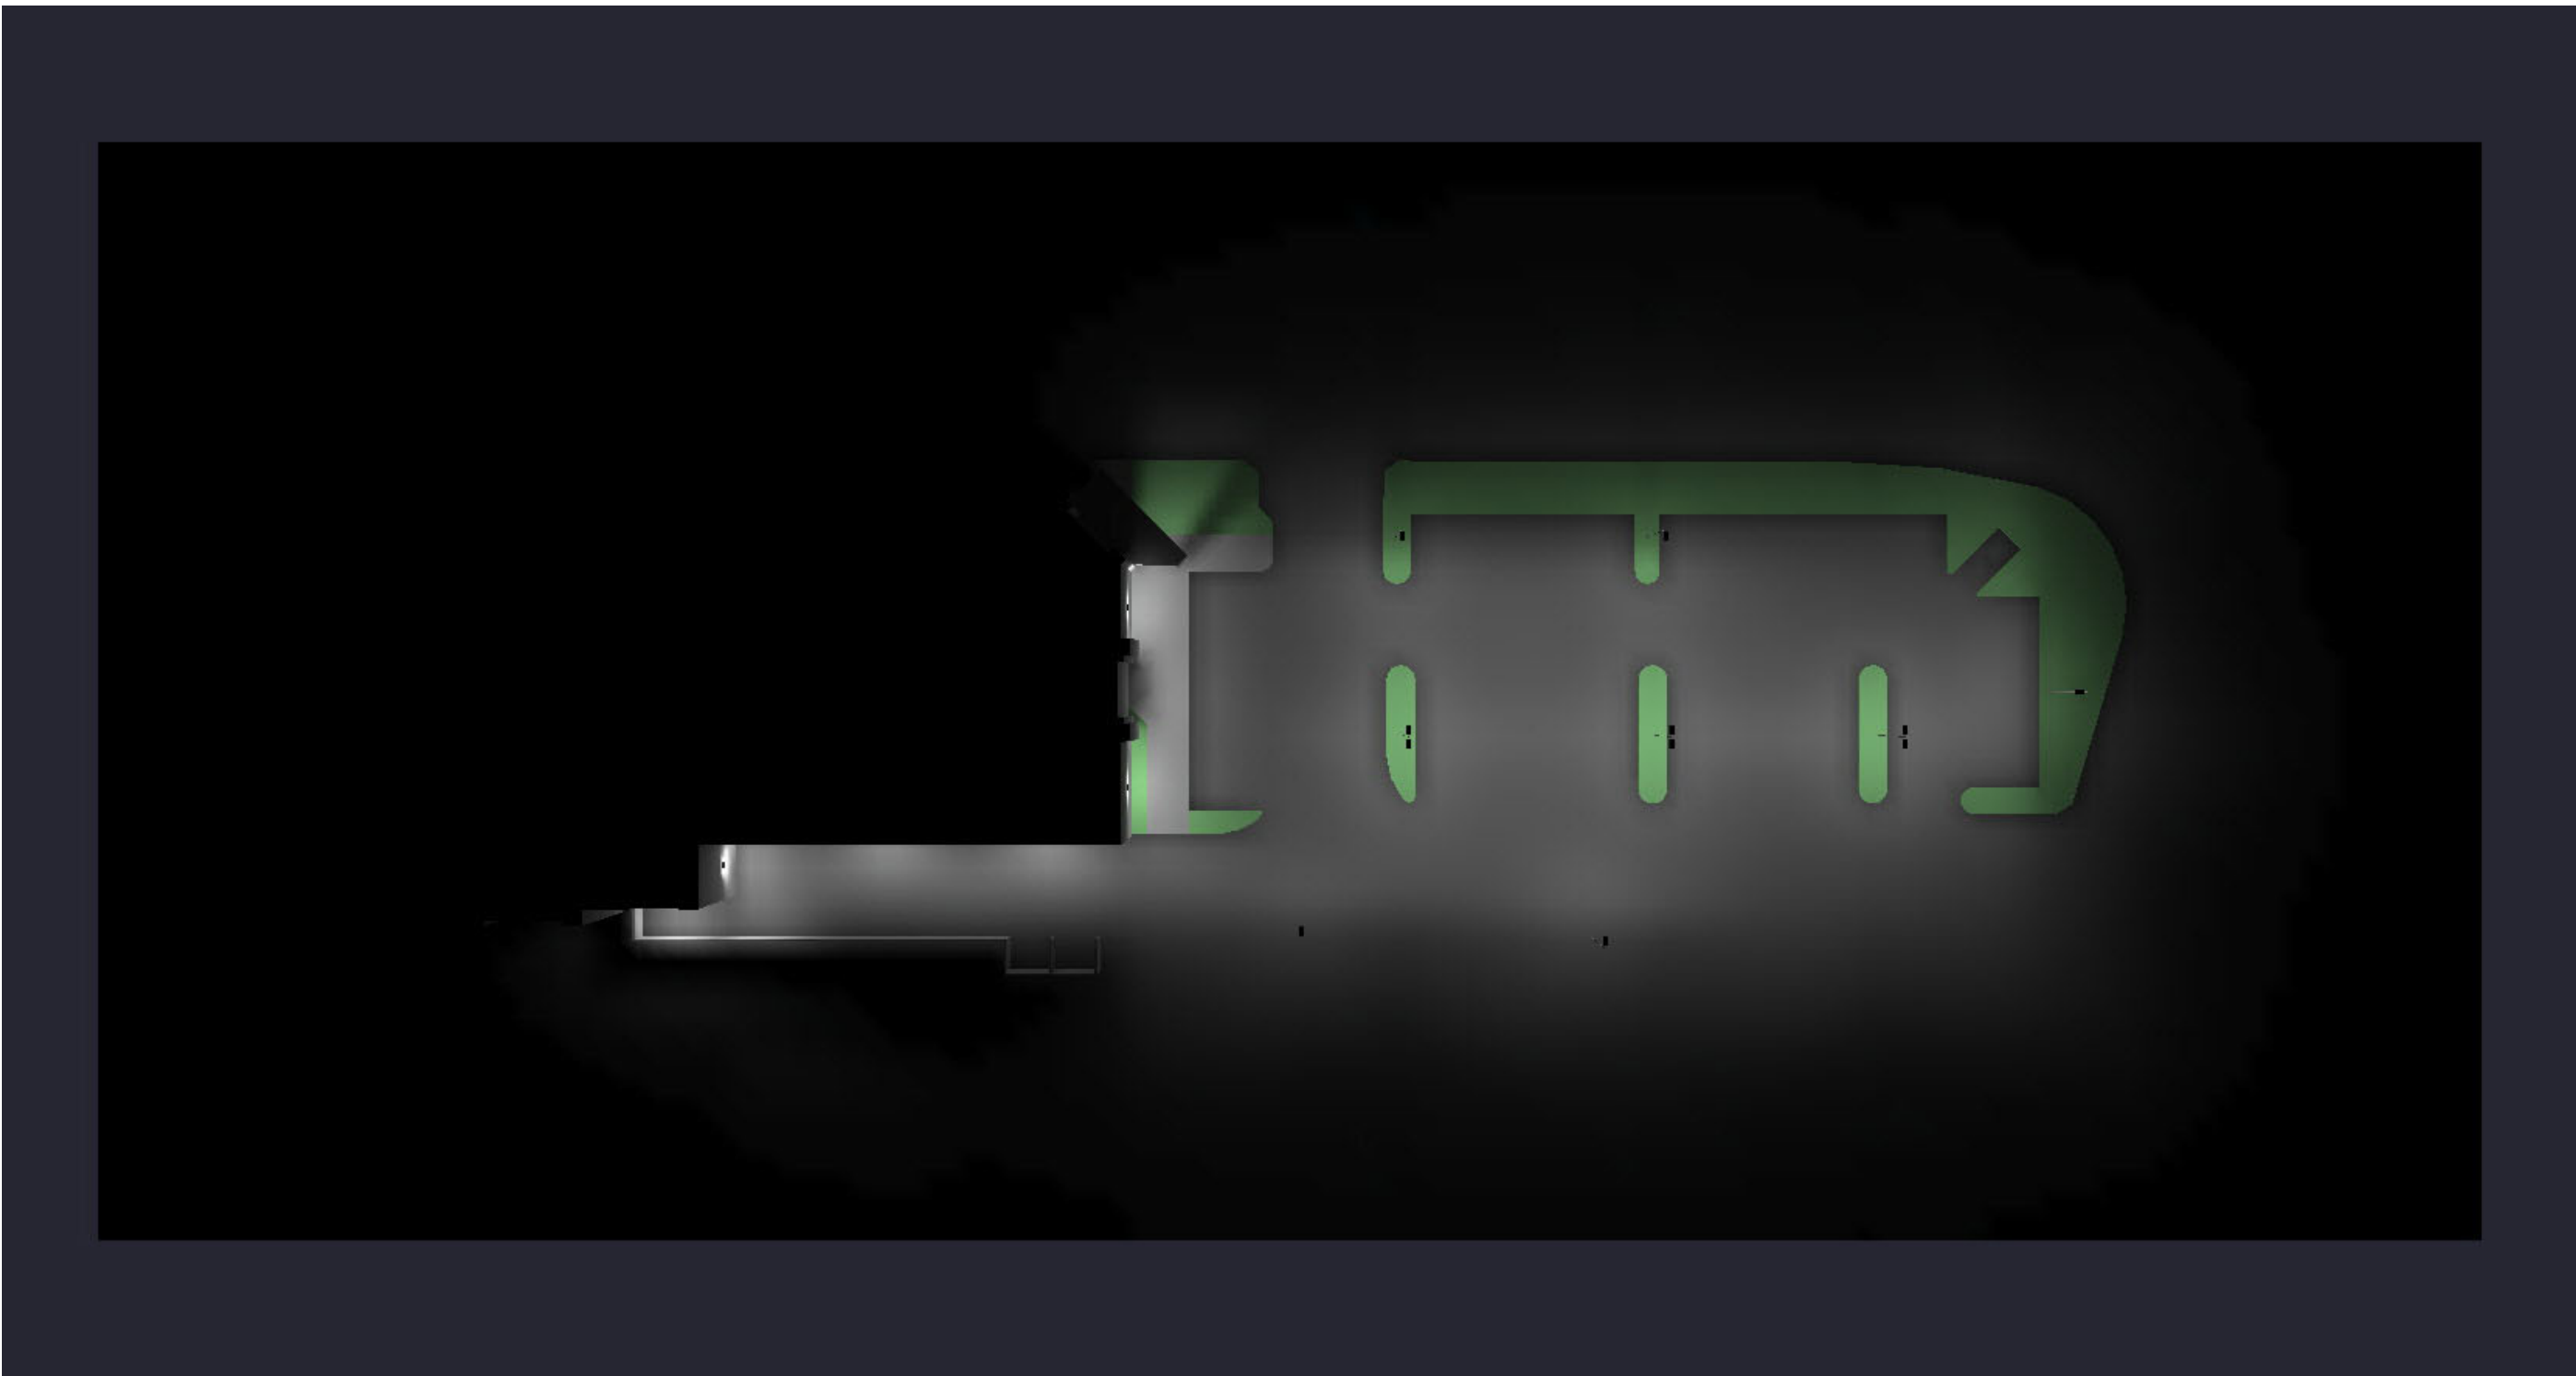

Plan View Grayscale

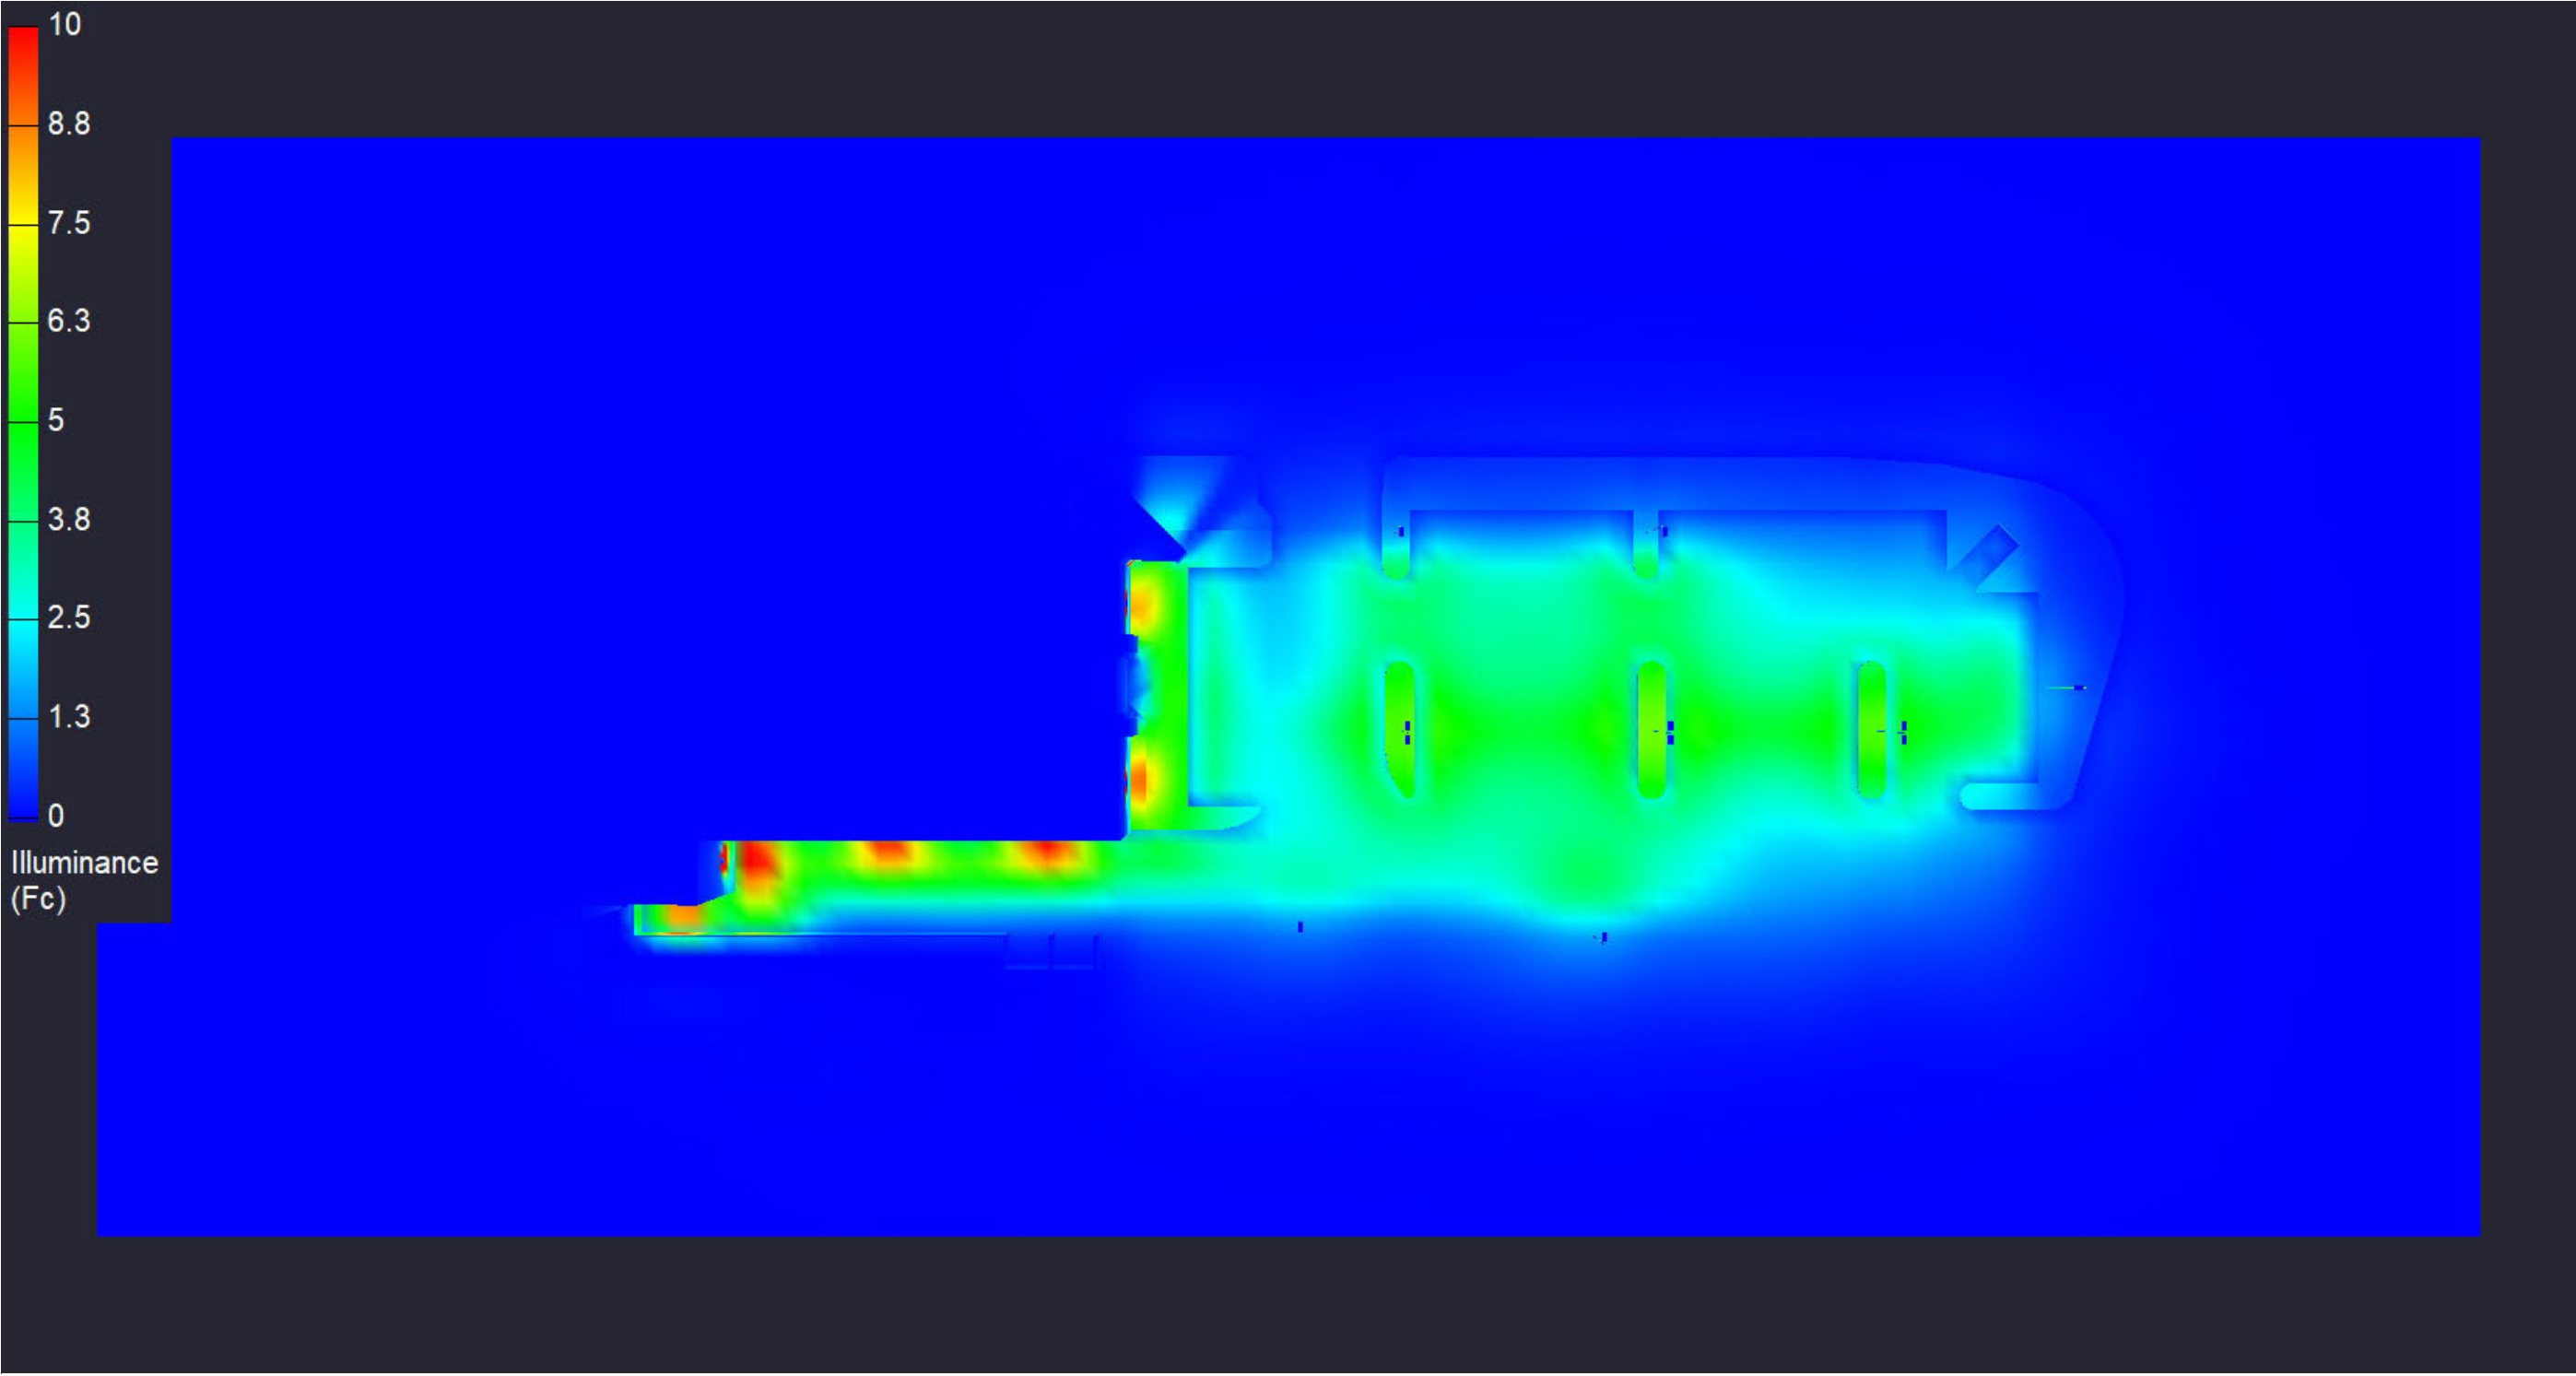

Plan View Pseudo

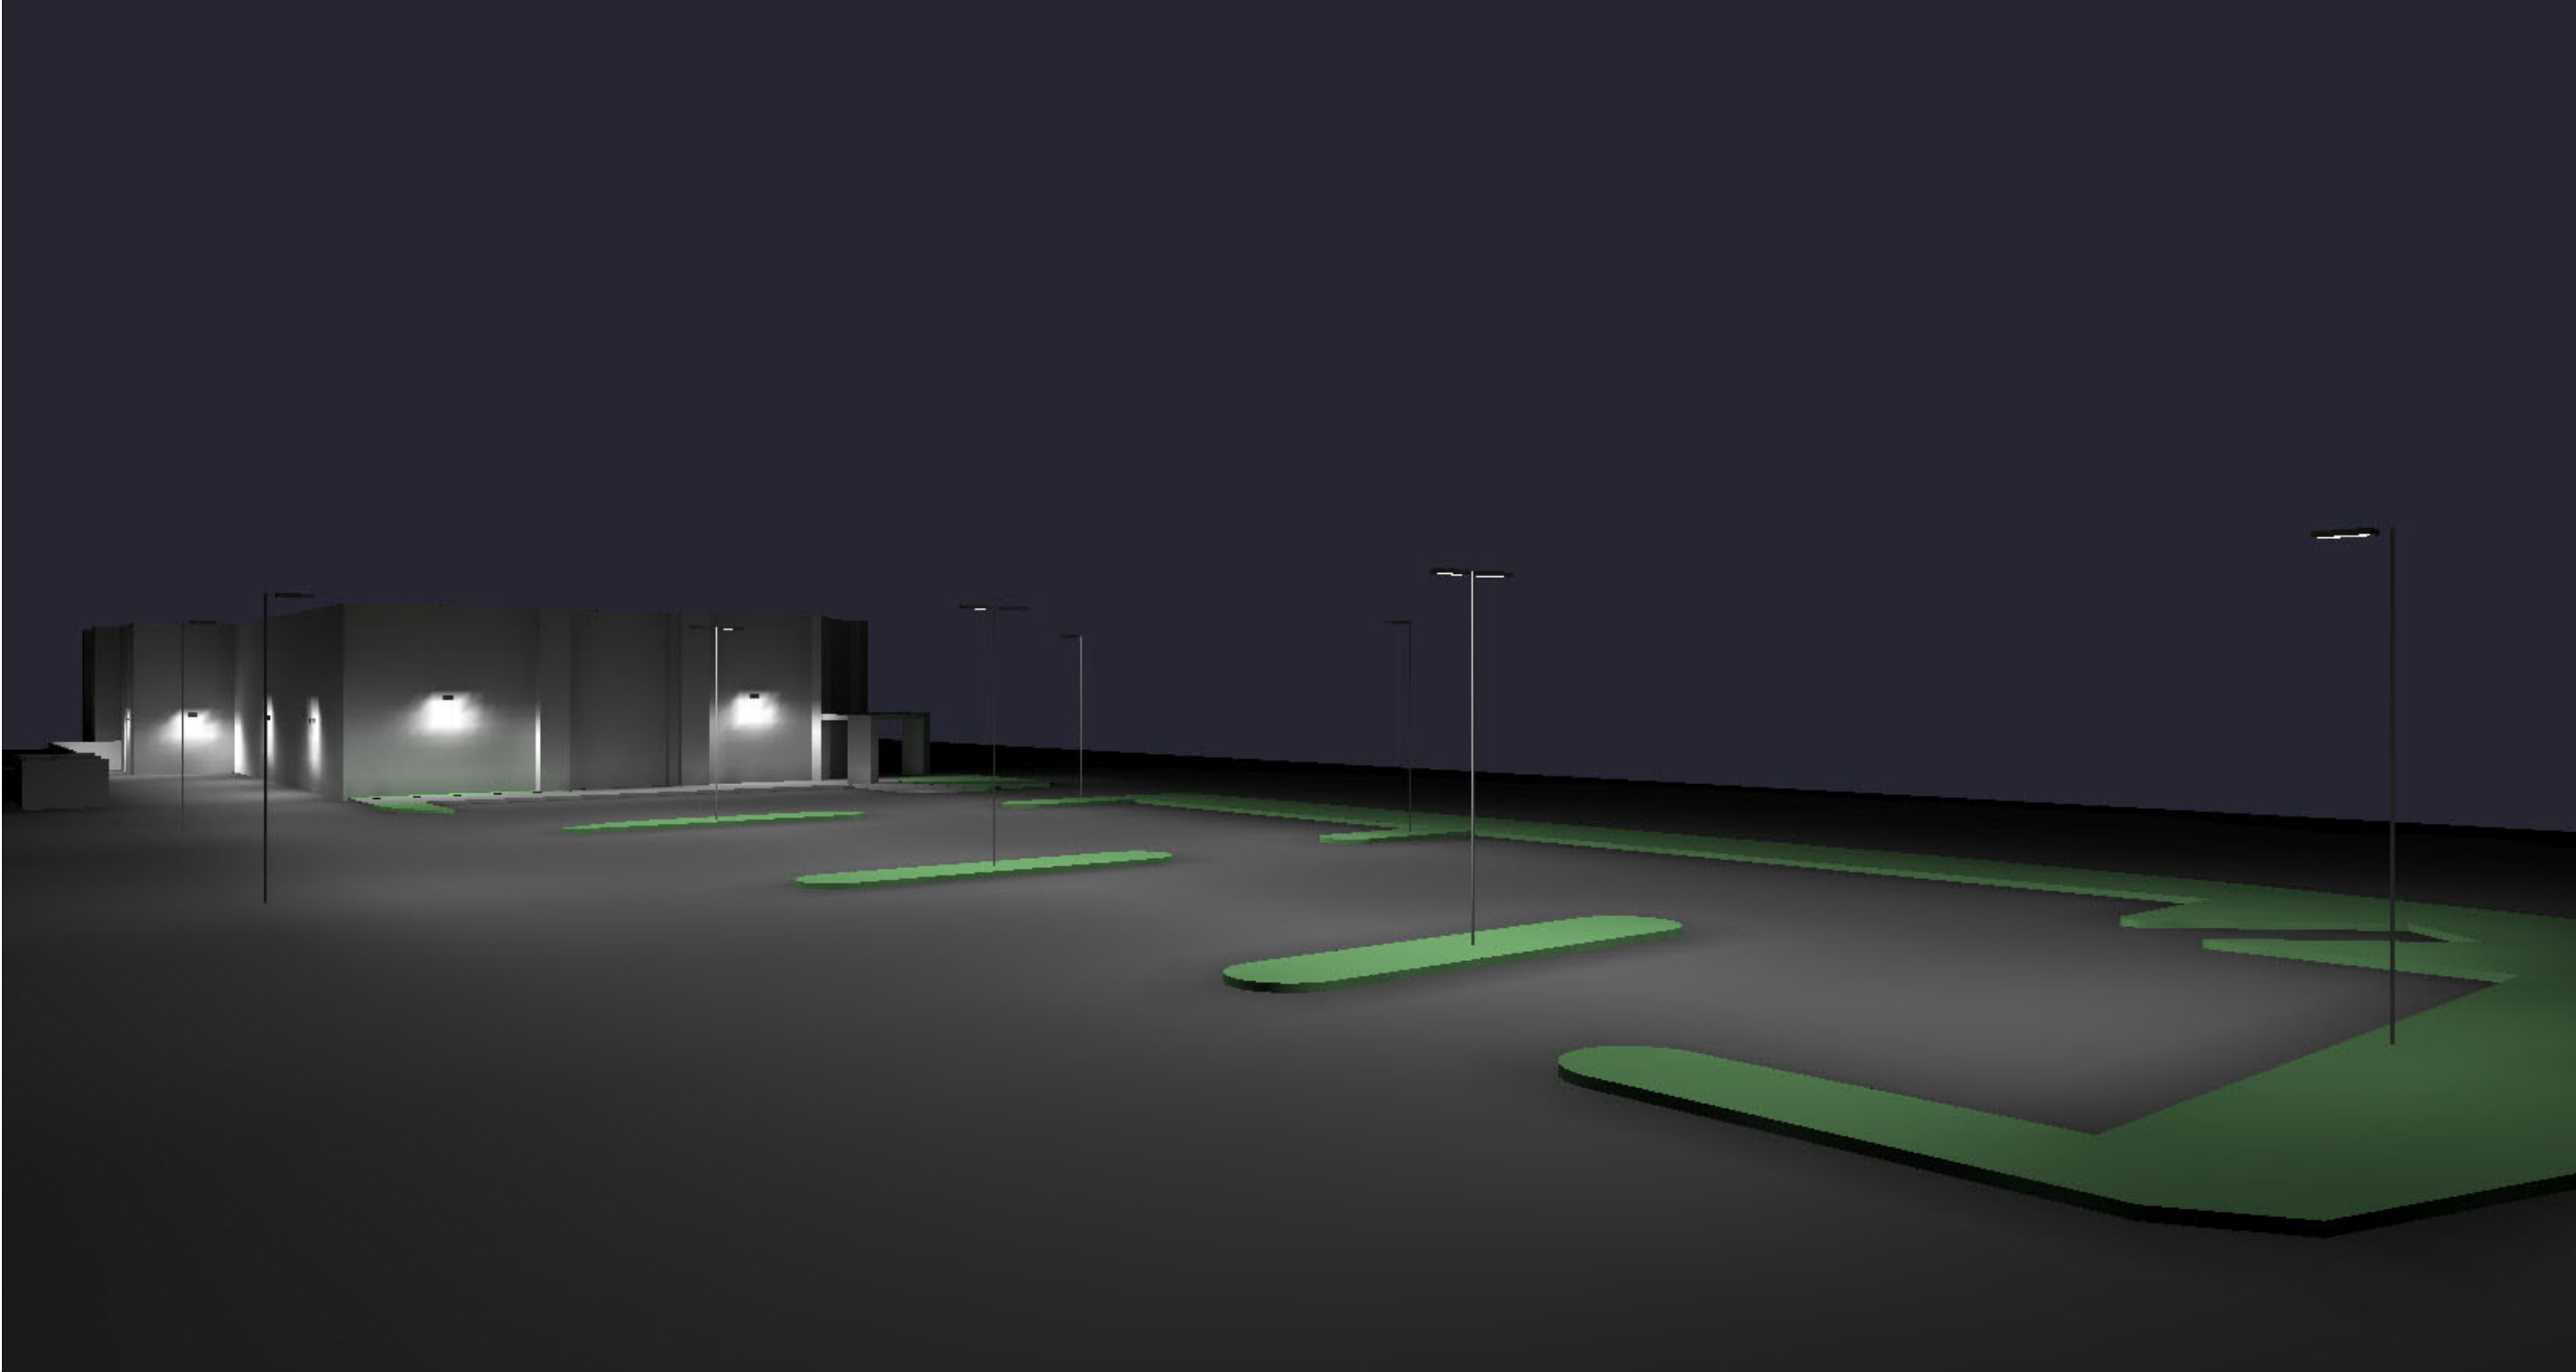

Side View

FIXTURE SCHEDULE

Luminaire Schedule								
Qty	Symbol	Label	Arrangement	Description	Lum. Watts	Total Watts	Lum. Lumens	LLF
1		P5-40k	SINGLE	Area Lighter / Acuity / RSX2 LED P1 40K R3 MVOLT RPA HS NLTAIR2 PIRHN DDBXD	72.0642	72.064	8107	0.900
3		P6 - B2B	Back-Back	Area Lighter / Acuity / RSX2 LED P1 40K R4	72.06	432.36	11135	0.900
4		P7	SINGLE	Area Lighter / Acuity / RSX2 LED P1 40K R4 HS	72.0642	288.257	7753	0.900
1		WP-1-40k	SINGLE	Wallpack / Acuity / WDGE2 LED P4 40K 80CRI VW MVOLT SRM DDBXD	34.96	34.96	4528	0.900
5		WP-2-40k	SINGLE	Wallpack / Acuity / WDGE3 LED P2 40K 80CRI R3 MVOLT SRM NLTAIR2PIR DDBXD	59.2761	296.381	8519	0.900

STATISTICAL SUMMARY

LPD Area Summary			
Label	Area	Total Watts	LPD
GO Fort Braggs CA	80083	1124.022	0.014

Calculation Summary							
Label	CalcType	Units	Avg	Max	Min	Avg/Min	Max/Min
Parking Lot	Illuminance	Fc	3.13	7.0	0.5	6.26	14.00
Plan East Entrance	Illuminance	Fc	1.18	2.4	0.5	2.36	4.80
Plan North Entrance	Illuminance	Fc	0.94	4.0	0.2	4.70	20.00
Property Line	Illuminance	Fc	0.14	0.5	0.0	N.A.	N.A.
Truck Well	Illuminance	Fc	9.12	27.5	2.4	3.80	11.46



Head Office
400 S. Record St.
Dallas, TX 75202

Facade and Site Lighting Layout

GROCERY OUTLET
Fort Braggs, CA

DESIGNER: CR
DATE: 05.03.2022
REV: 1
SCALE: 1" = 14'

L03